
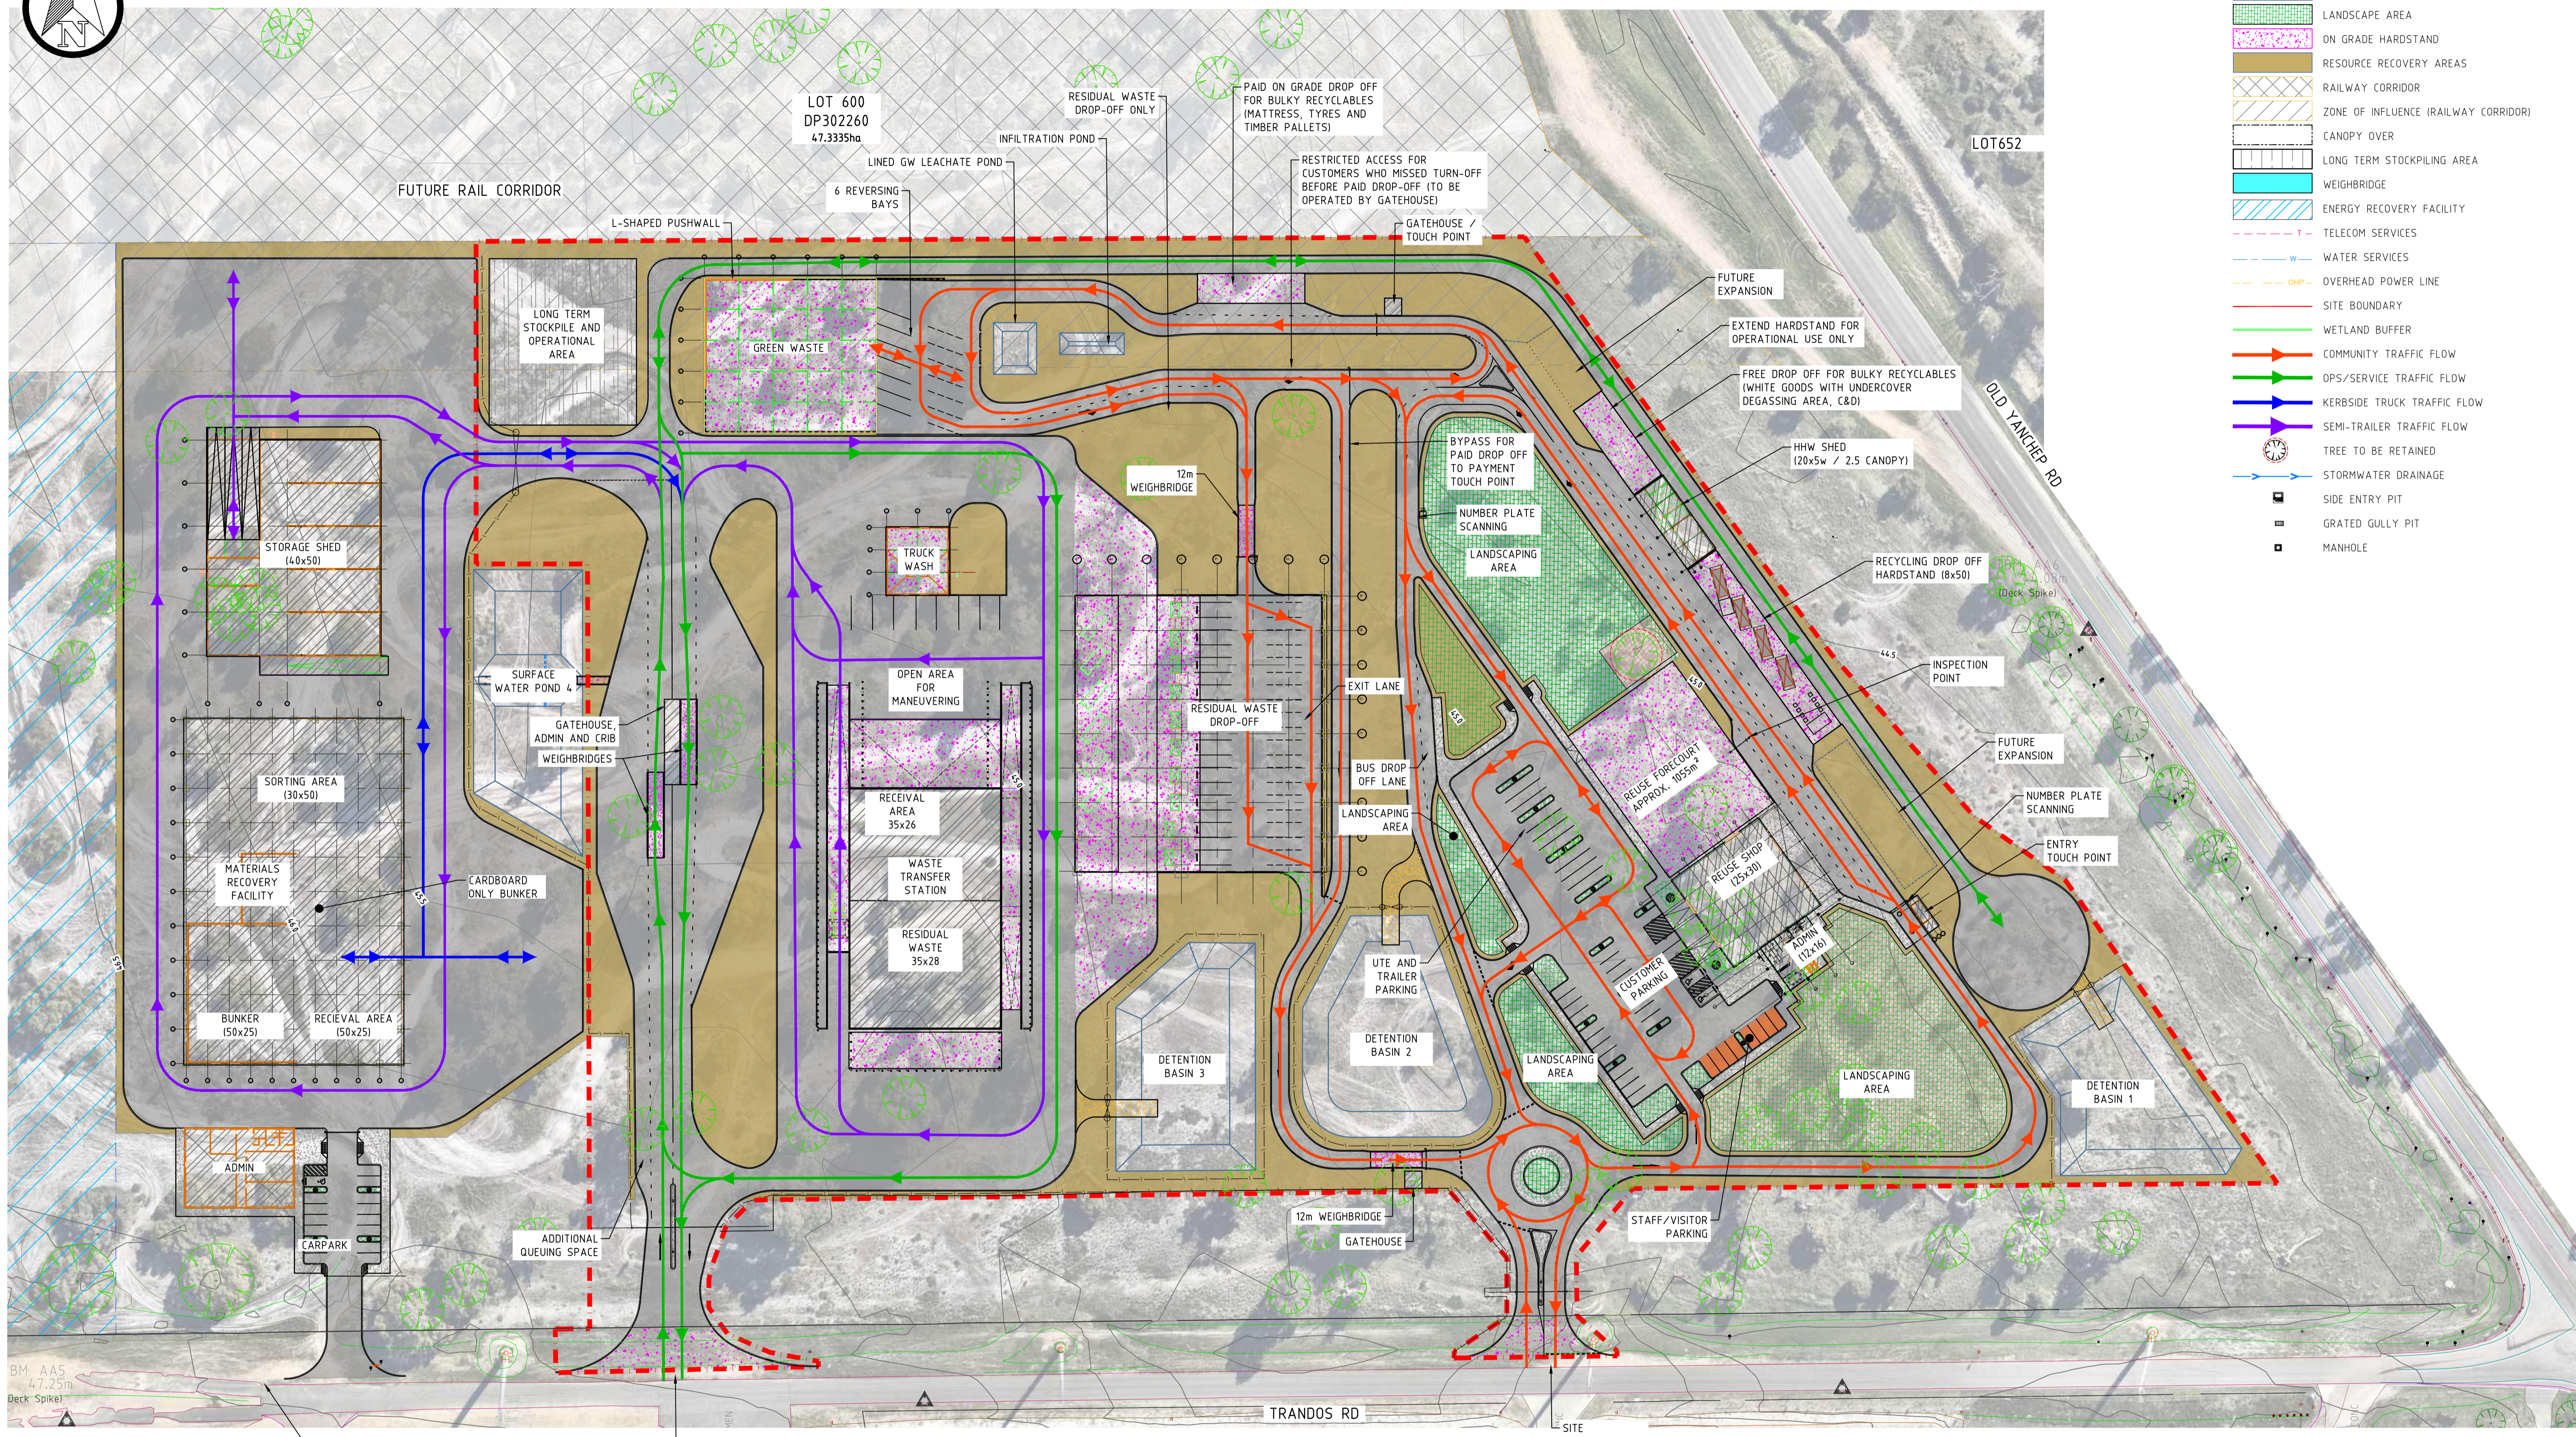


FILENAME: \\SERVER\TALES\SECTIONS\ENGINEERING\PROJECTS\TC25017\DRAWINGS\TC25017_CONCEPT.DWG
 PRINTED BY: Armand Bester on 12.08.2025 11:13 AM

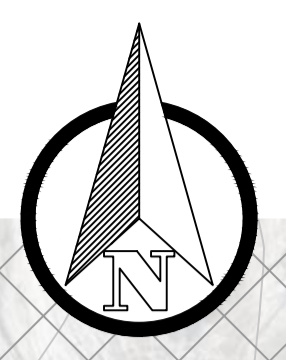


LEGEND:

[Symbol]	SEALED ROAD
[Symbol]	ENCLOSED BUILDINGS
[Symbol]	MRF AND WTS BUILDINGS
[Symbol]	STORMWATER PONDS
[Symbol]	LANDSCAPE AREA
[Symbol]	ON GRADE HARDSTAND
[Symbol]	RESOURCE RECOVERY AREAS
[Symbol]	RAILWAY CORRIDOR
[Symbol]	ZONE OF INFLUENCE (RAILWAY CORRIDOR)
[Symbol]	CANOPY OVER
[Symbol]	LONG TERM STOCKPILING AREA
[Symbol]	WEIGHBRIDGE
[Symbol]	ENERGY RECOVERY FACILITY
[Symbol]	TELECOM SERVICES
[Symbol]	WATER SERVICES
[Symbol]	OVERHEAD POWER LINE
[Symbol]	SITE BOUNDARY
[Symbol]	WETLAND BUFFER
[Symbol]	COMMUNITY TRAFFIC FLOW
[Symbol]	OPS/SERVICE TRAFFIC FLOW
[Symbol]	KERBSIDE TRUCK TRAFFIC FLOW
[Symbol]	SEMI-TRAILER TRAFFIC FLOW
[Symbol]	TREE TO BE RETAINED
[Symbol]	STORMWATER DRAINAGE
[Symbol]	SIDE ENTRY PIT
[Symbol]	GRADED GULLY PIT
[Symbol]	MANHOLE

SURVEY REFERENCE: MALONEY SURVEYING
 DATE: 07.05.2025
 VERTICAL DATUM: AUSTRALIAN HEIGHT DATUM
 HORIZONTAL DATUM: MGA 2020 ZONE 50

PRELIMINARY ONLY
 NOT FOR CONSTRUCTION

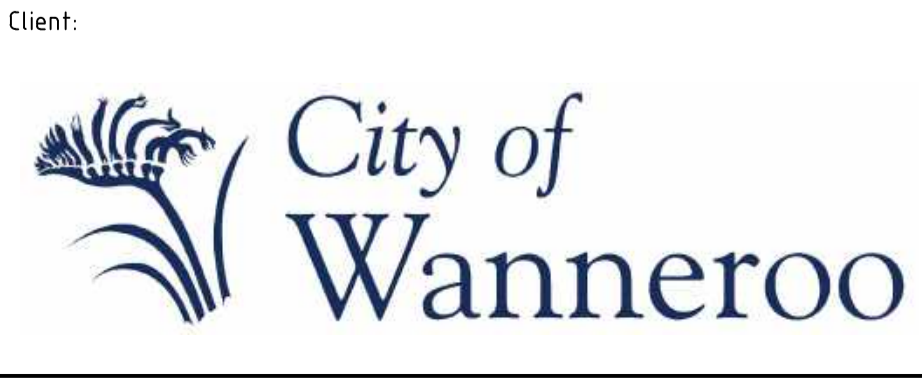

NOTES






- This drawing is the property of Talis Consultants Pty Ltd. It is a confidential document and must not be copied, used, or its contents divulged without prior written consent.
- DO NOT SCALE, use figured dimensions only, if in doubt please contact Talis Consultants.
- Parts of this drawing is intended to be IN COLOUR. Black & White Printing may cause errors or omissions. If this text is not GREEN, please contact Talis Consultants.

No.	Date	By	App.	Amendment / Issue
C	02.02.2026	AB	SM	RESIDUAL WASTE DROP OFF AREA REVISED
B	13.08.2025	YJ	AB	COMMENTS UPDATED
A	07.08.2025	YJ	AB	PRELIMINARY ISSUE

Project: **NEERABUP RRP CONCEPT DESIGN**
 Title: **WTS, MRF AND CRC CONCEPT LAYOUT**


Scale: AS SHOWN @ A1 Date: 07.08.2025
 Drawn: YJ Checked: AB Approved: [Signature]
 Job No: TC25017 Drg. No: C-500 Rev: C
 Filename: TC25017_CONCEPT.DWG

FILENAME: \\SERVER\TALES\SECTIONS\ENGINEERING\PROJECTS\TC25017 - NRRP - DETAILED DESIGN\DRAWINGS\1. DRAWINGS\TC25017_CONCEPT.DWG
 PRINTED BY: Amanda Bester on 12.08.2025 11:12 AM

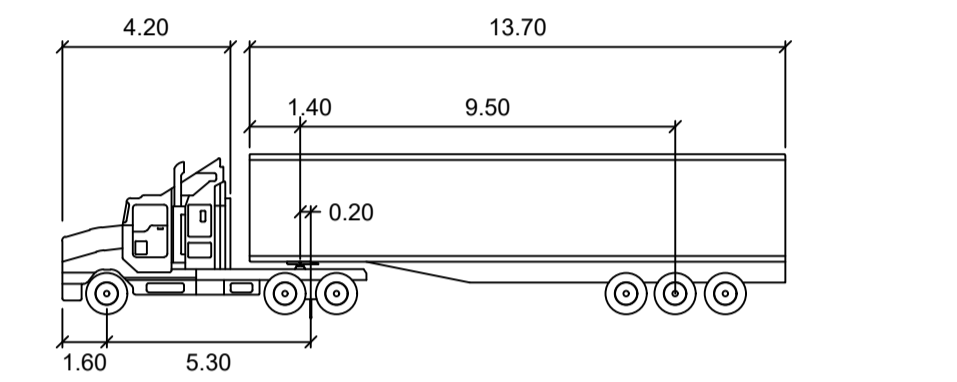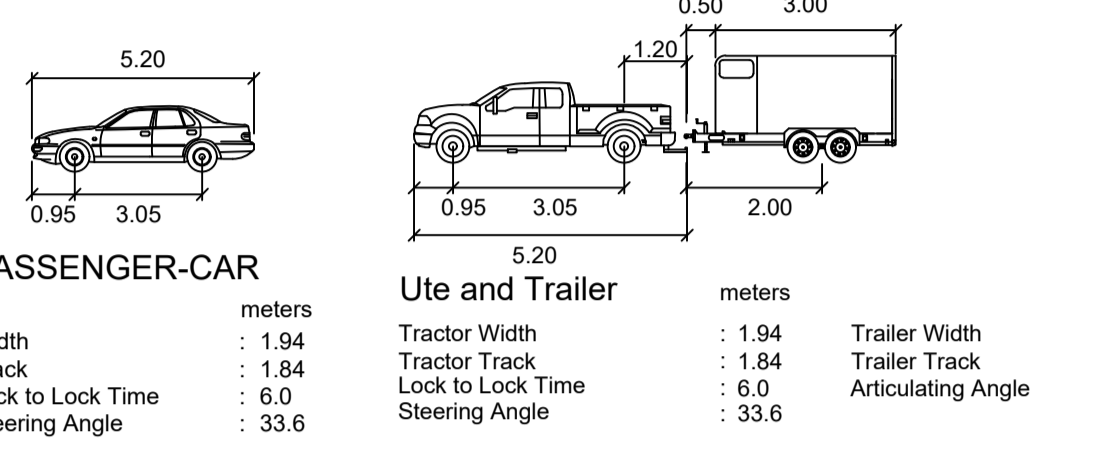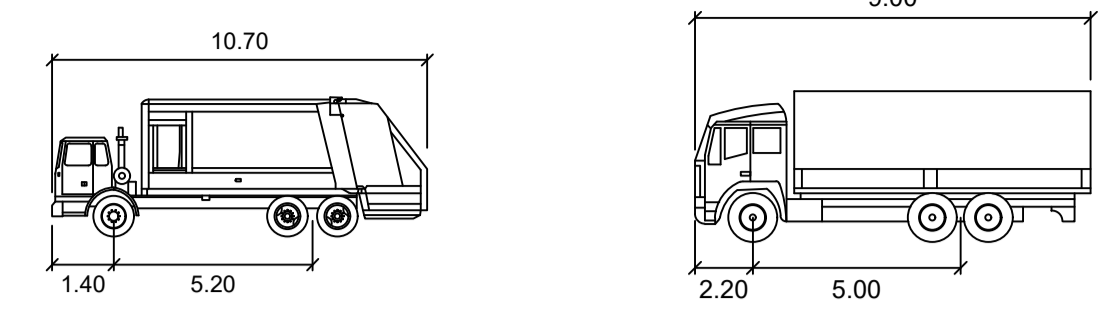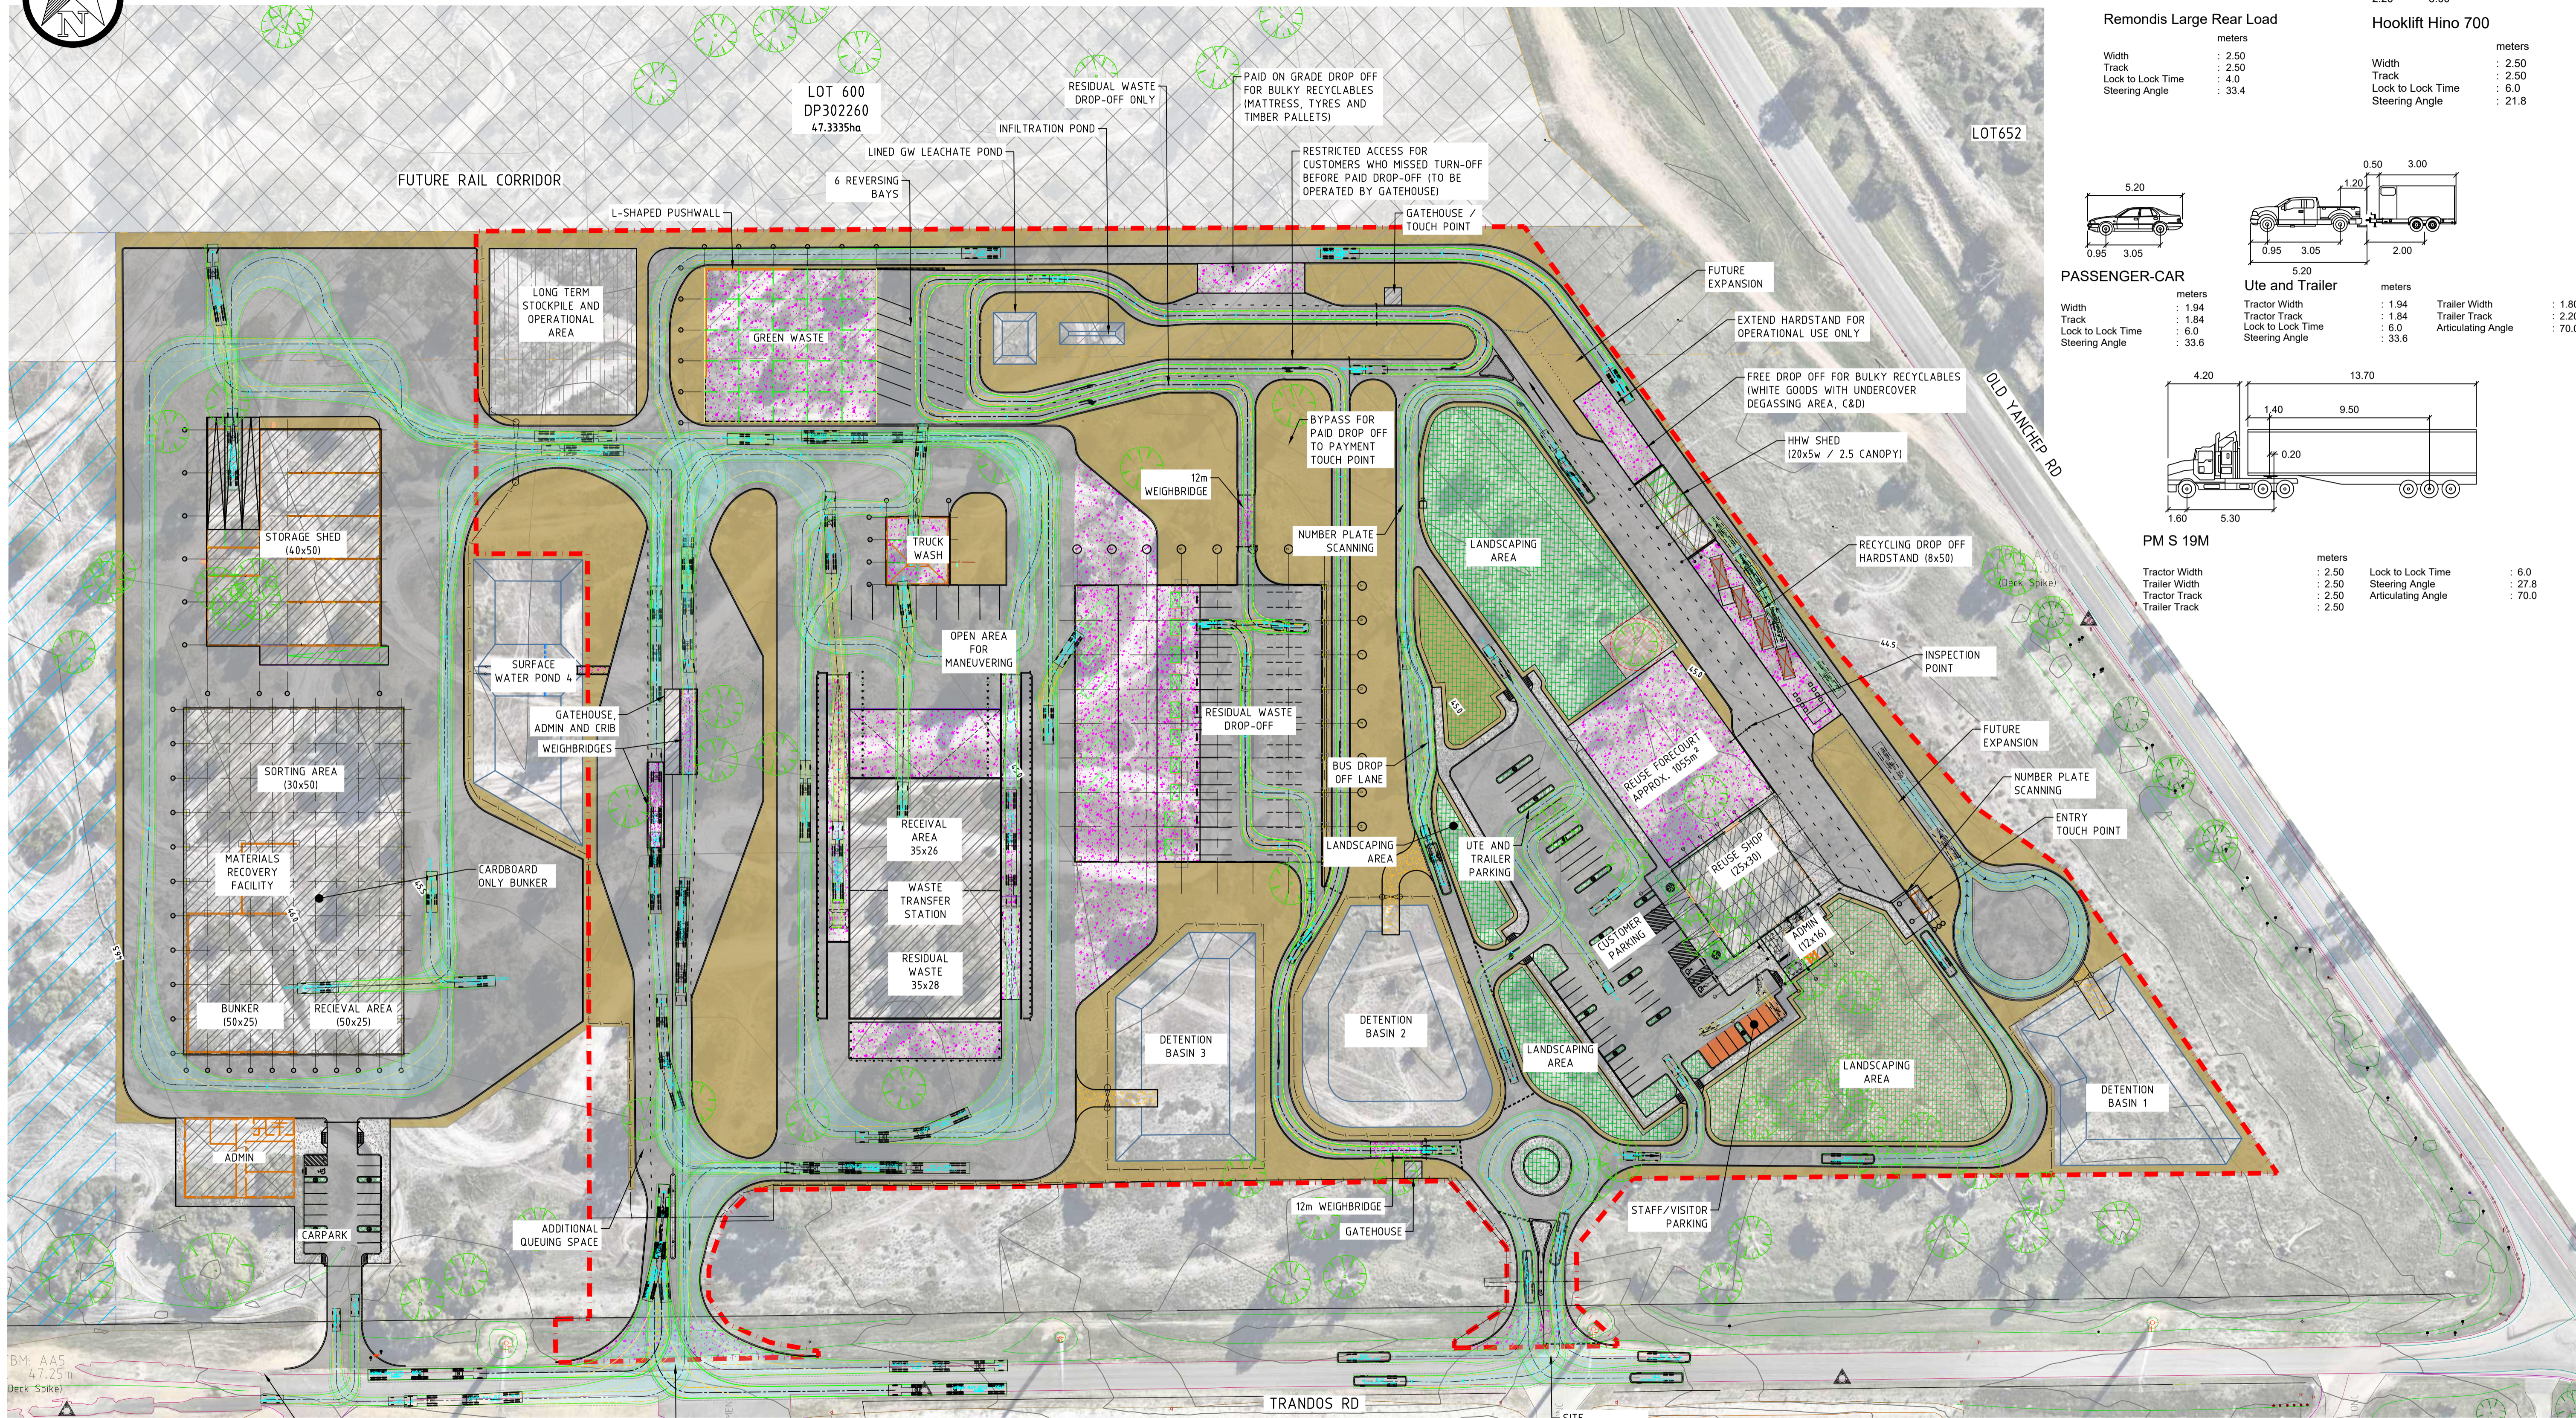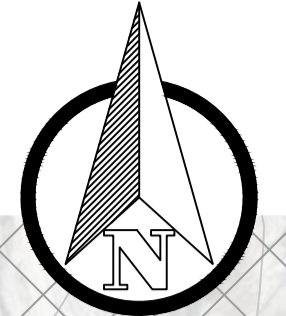

SURVEY REFERENCE: MALONEY SURVEYING
 DATE: 07.05.2025
 VERTICAL DATUM: AUSTRALIAN HEIGHT DATUM
 HORIZONTAL DATUM: MGA 2020 ZONE 50

PRELIMINARY ONLY
 NOT FOR CONSTRUCTION

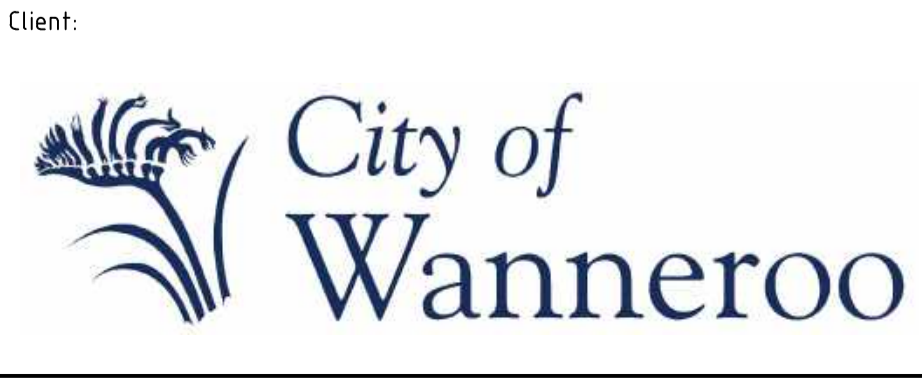

NOTES
 1. This drawing is the property of Talis Consultants Pty Ltd. It is a confidential document and must not be copied, used, or its contents divulged without prior written consent.
 2. DO NOT SCALE, use figured dimensions only, if in doubt please contact Talis Consultants.
 3. Parts of this drawing is intended to be IN COLOUR. Black & White Printing may cause errors or omissions. If this text is not GREEN, please contact Talis Consultants.



No.	Date	By	Issue	App.
C	02.02.2026	AB	SH RESIDUAL WASTE DROPP OFF REVISED	
B	13.08.2025	YJ	AB COMMENTS UPDATED	
A	07.08.2025	YJ	AB PRELIMINARY ISSUE	

Project: **NEERABUP RRP CONCEPT DESIGN**

Title: **WTS, MRF AND CRC CONCEPT SWEEP PATH**

Scale: AS SHOWN @ A1	Date: 07.08.2025	
Drawn: YJ	Checked: AB	Approved:
Job No: TC25017	Drg. No: C-501	Rev: C
Filename: TC25017_CONCEPT.DWG		

FILENAME: \\SERVER\TALES\SECTIONS\ENGINEERING\PROJECTS\TC25017 - NRRP - DETAILED DESIGN\DRAWINGS\1_DRAWINGS\TC25017_CONCEPT.DWG
 Printed by Armand Bester on 12.08.2025 11:11 AM

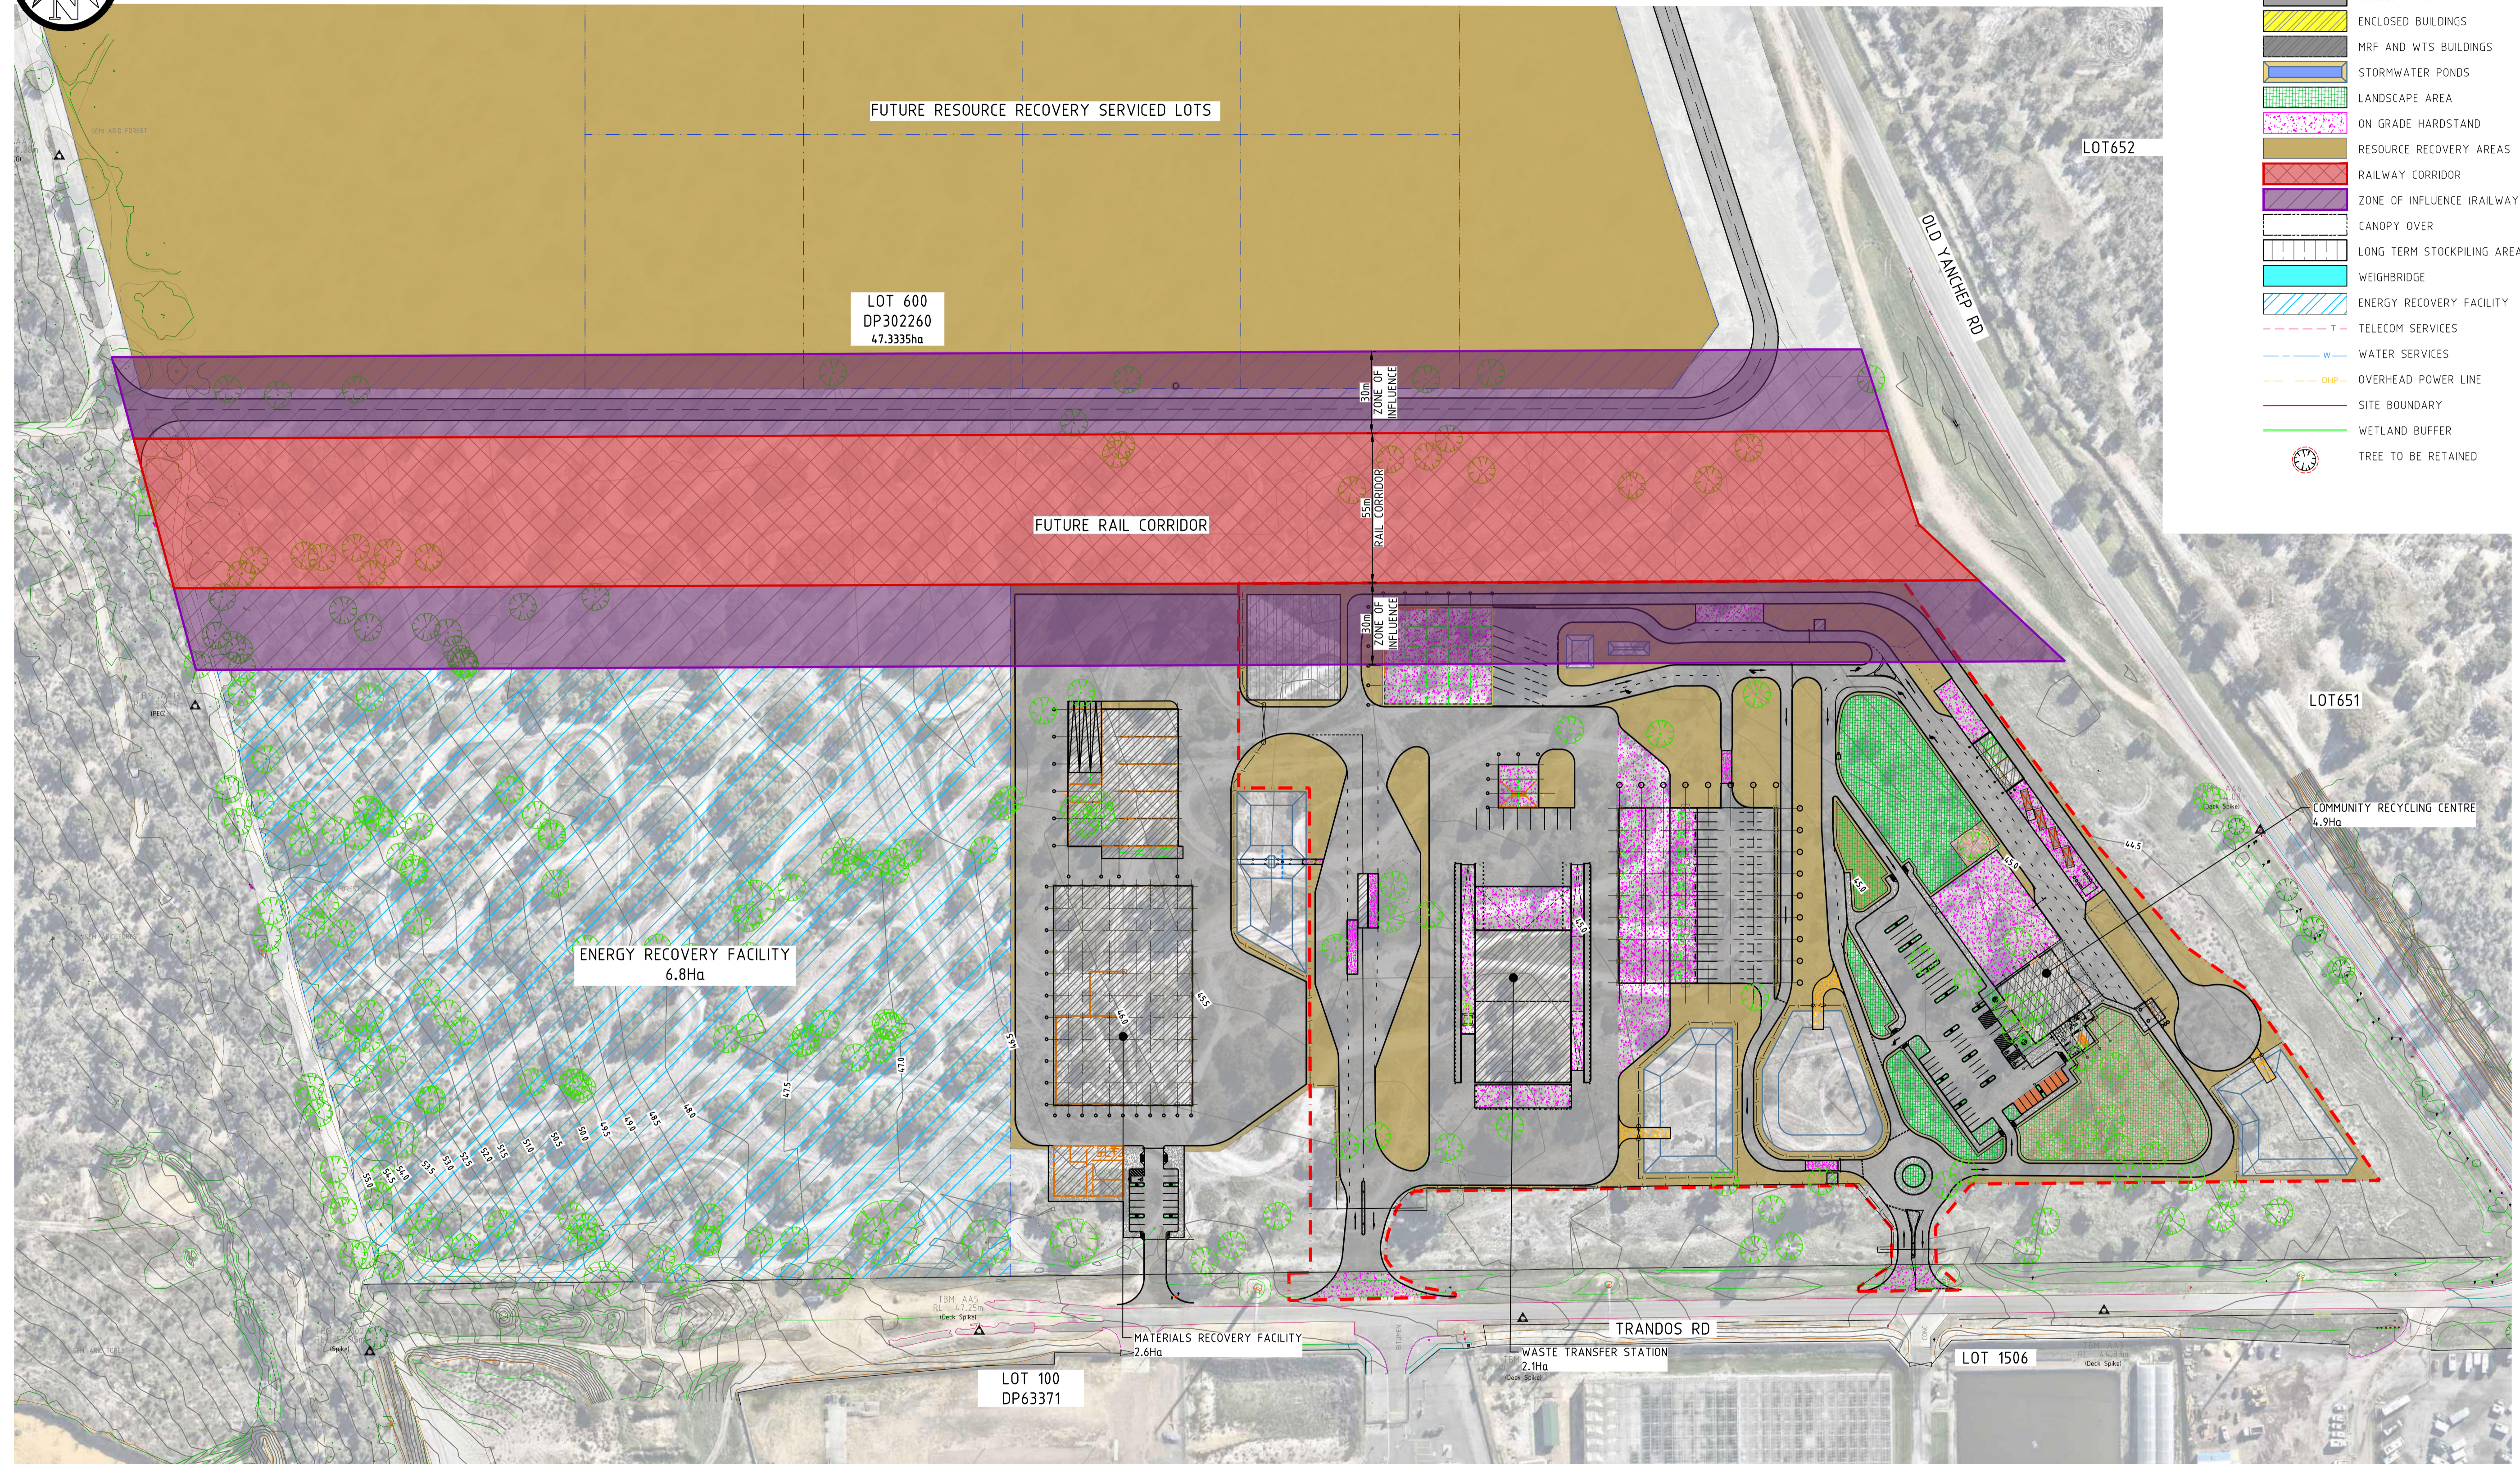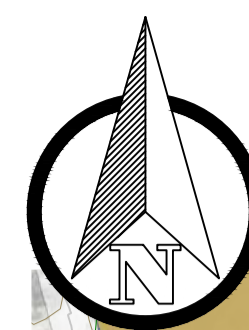


LEGEND:

[Symbol]	SEALED ROAD
[Symbol]	ENCLOSED BUILDINGS
[Symbol]	MRF AND WTS BUILDINGS
[Symbol]	STORMWATER PONDS
[Symbol]	LANDSCAPE AREA
[Symbol]	ON GRADE HARDSTAND
[Symbol]	RESOURCE RECOVERY AREAS
[Symbol]	RAILWAY CORRIDOR
[Symbol]	ZONE OF INFLUENCE (RAILWAY CORRIDOR)
[Symbol]	CANOPY OVER
[Symbol]	LONG TERM STOCKPILING AREA
[Symbol]	WEIGHBRIDGE
[Symbol]	ENERGY RECOVERY FACILITY
[Symbol]	TELECOM SERVICES
[Symbol]	WATER SERVICES
[Symbol]	OVERHEAD POWER LINE
[Symbol]	SITE BOUNDARY
[Symbol]	WETLAND BUFFER
[Symbol]	TREE TO BE RETAINED

SURVEY REFERENCE: MALONEY SURVEYING
 DATE: 07.05.2025
 VERTICAL DATUM: AUSTRALIAN HEIGHT DATUM
 HORIZONTAL DATUM: MGA 2020 ZONE 50

PRELIMINARY ONLY
 NOT FOR CONSTRUCTION

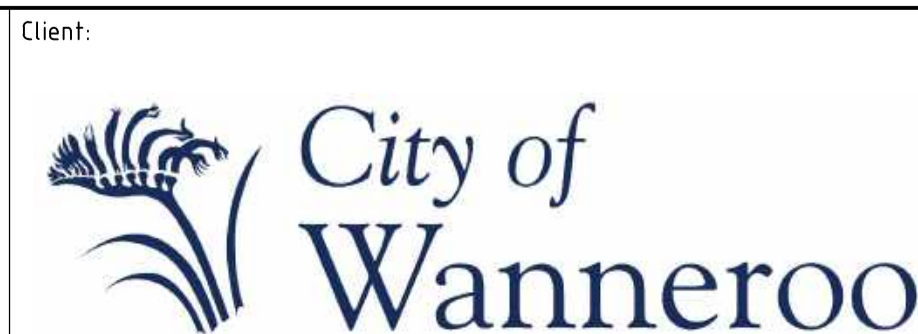

NOTES


- This drawing is the property of Talis Consultants Pty Ltd. It is a confidential document and must not be copied, used, or its contents divulged without prior written consent.
- DO NOT SCALE, use figured dimensions only, if in doubt please contact Talis Consultants.
- Parts of this drawing is intended to be IN COLOUR. Black & White Printing may cause errors or omissions. If this text is not GREEN, please contact Talis Consultants

No.	Date	By	App.	Amendment / Issue
B	02.02.2026	AB	SM	RESIDUAL WASTE DROP OFF REVISED
A	13.08.2025	YJ	AB	PRELIMINARY ISSUE


Project: **NEERABUP RRP CONCEPT DESIGN**
 Title: **CONCEPT GENERAL ARRANGEMENT**

Scale: AS SHOWN @ A1 Date: 07.08.2025
 Drawn: YJ Checked: AB Approved:
 Job No: TC25017 Drg. No: C-502 Rev: B
 Filename: TC25017_CONCEPT.DWG

Printed by YJ on 11/02/2019 02:12 PM
 FILENAME: Y:\SECTIONS\WML\PROJECTS\TC25017\TC25017 - NRRP - DETAILED DESIGN\DRAWINGS\1 - DRAWINGS\TC25017.DWG

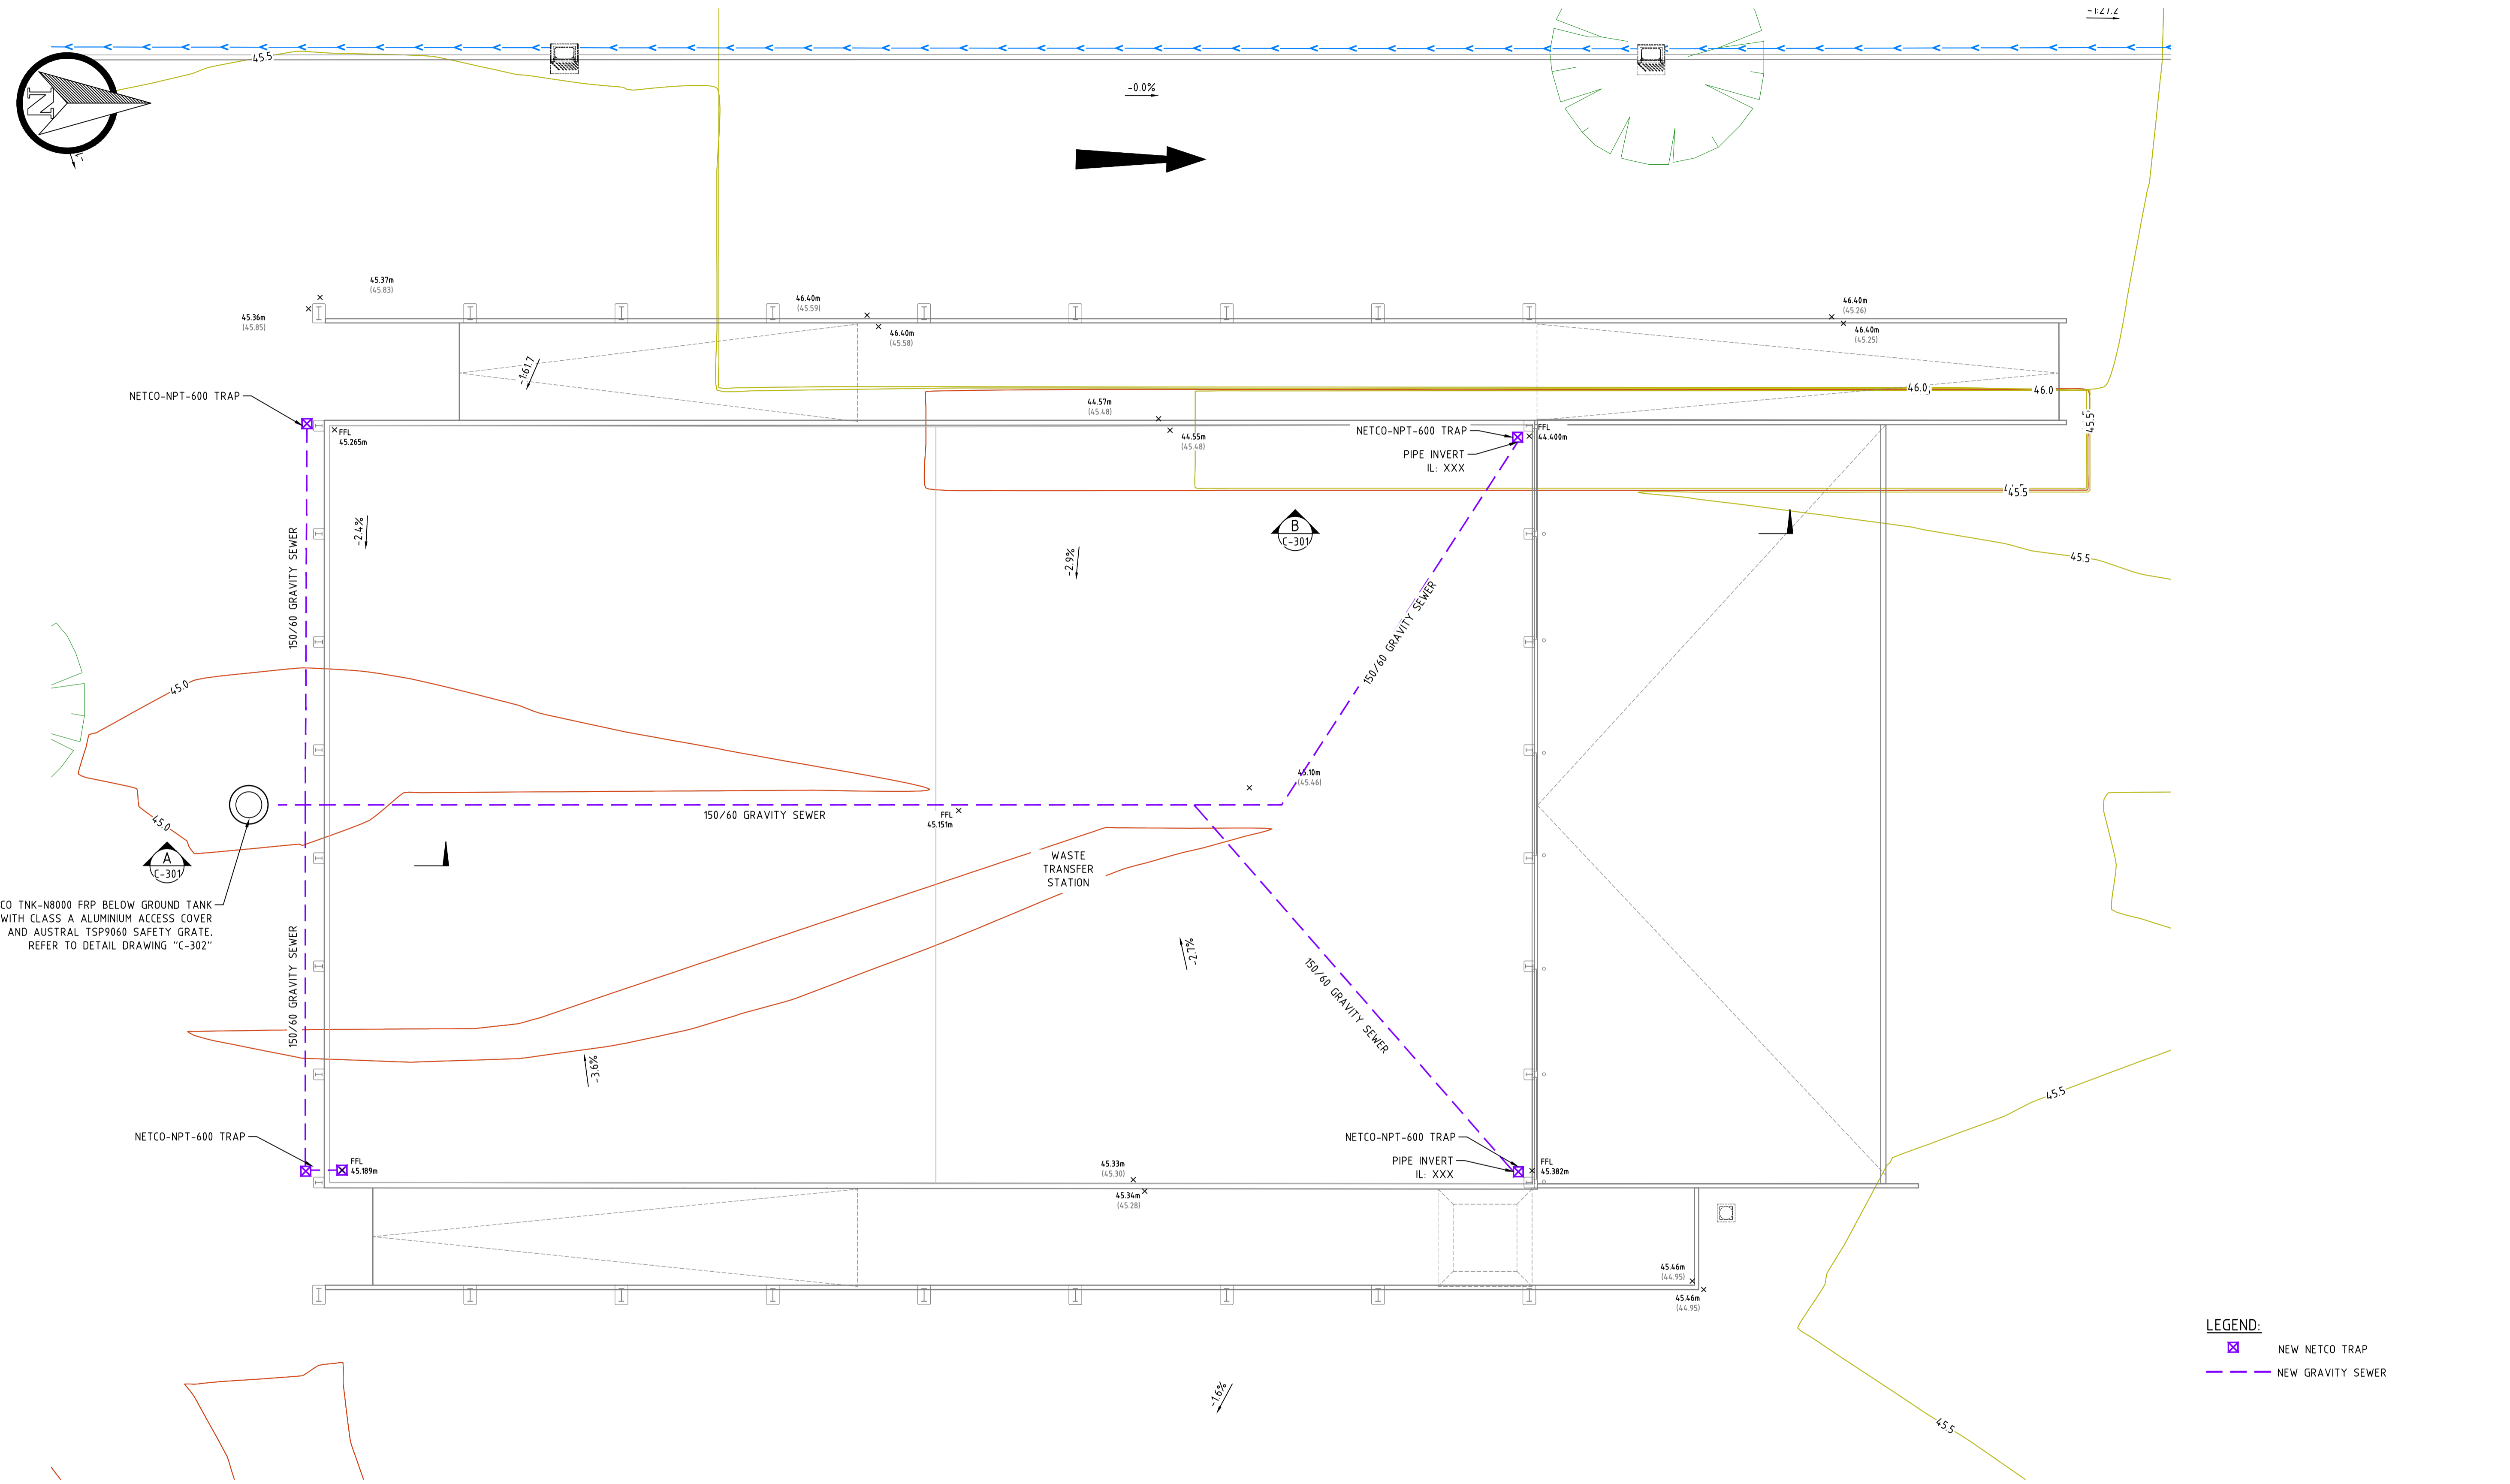

SURVEY REFERENCE: MALONEY SURVEYING
 DATE: 07.05.2025
 VERTICAL DATUM: AUSTRALIAN HEIGHT DATUM
 HORIZONTAL DATUM: MGA 2020 ZONE 50

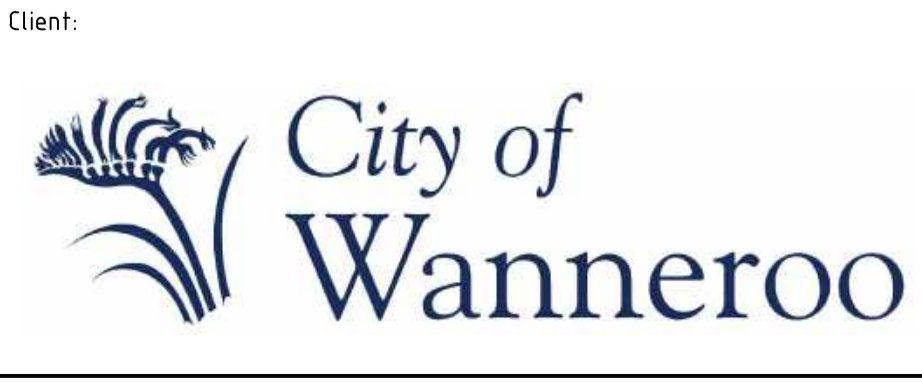

NOTES

- This drawing is the property of Talis Consultants Pty Ltd. It is a confidential document and must not be copied, used, or its contents divulged without prior written consent.
- DO NOT SCALE, use figured dimensions only, if in doubt please contact Talis Consultants.
- Parts of this drawing is intended to be IN COLOUR. Black & White Printing may cause errors or omissions. If this text is not GREEN, please contact Talis Consultants


No.	Date	By	Check	Amendment / Issue	App.
A	03.06.2025	YJ	AB	PRELIMINARY ISSUE	

Project: **NEERABUP RRP**


Title: **WTS DRAINAGE LAYOUT**

Scale: AS SHOWN @ A1	Date: 03.06.2025	
Drawn: YJ	Checked: AB	Approved:
Job No: TC25017	Drg. No: C-121	Rev: A
Filename: TC25017.DWG		

Printed by YJL on 11/02/2019 02:12 PM
 FILENAME: Y:\SECTIONS\CIVIL\PROJECTS\TC25017\TC25017 - NRRP - DETAILED DESIGN\DRAWINGS\1_DRAWINGS\TC25017.DWG


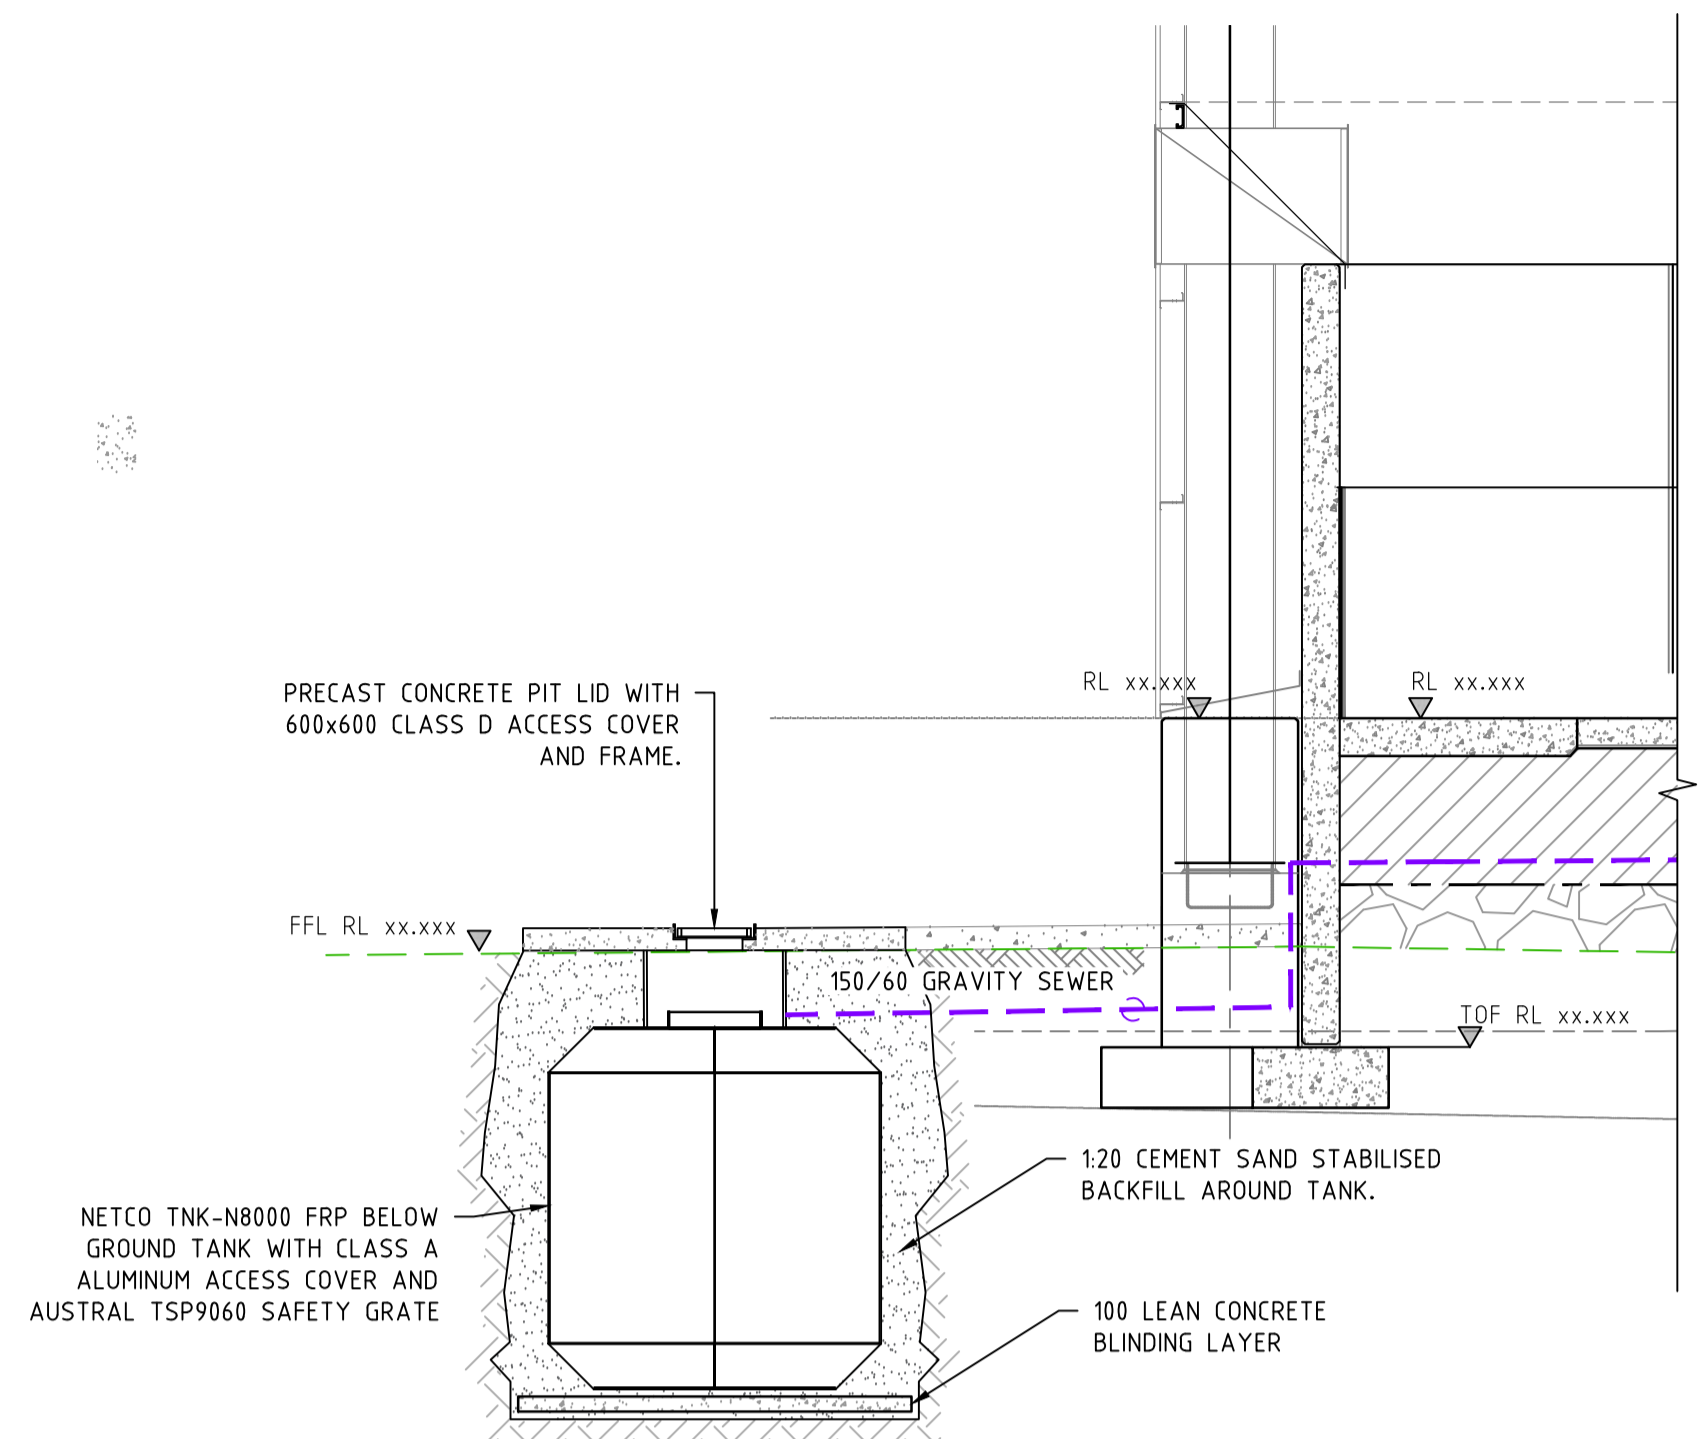


A SECTION - NETCO TNK-N8000 FRP BELOW GROUND TANK
 SCALE: 1:50
 REFER TO PLAN "C-121"

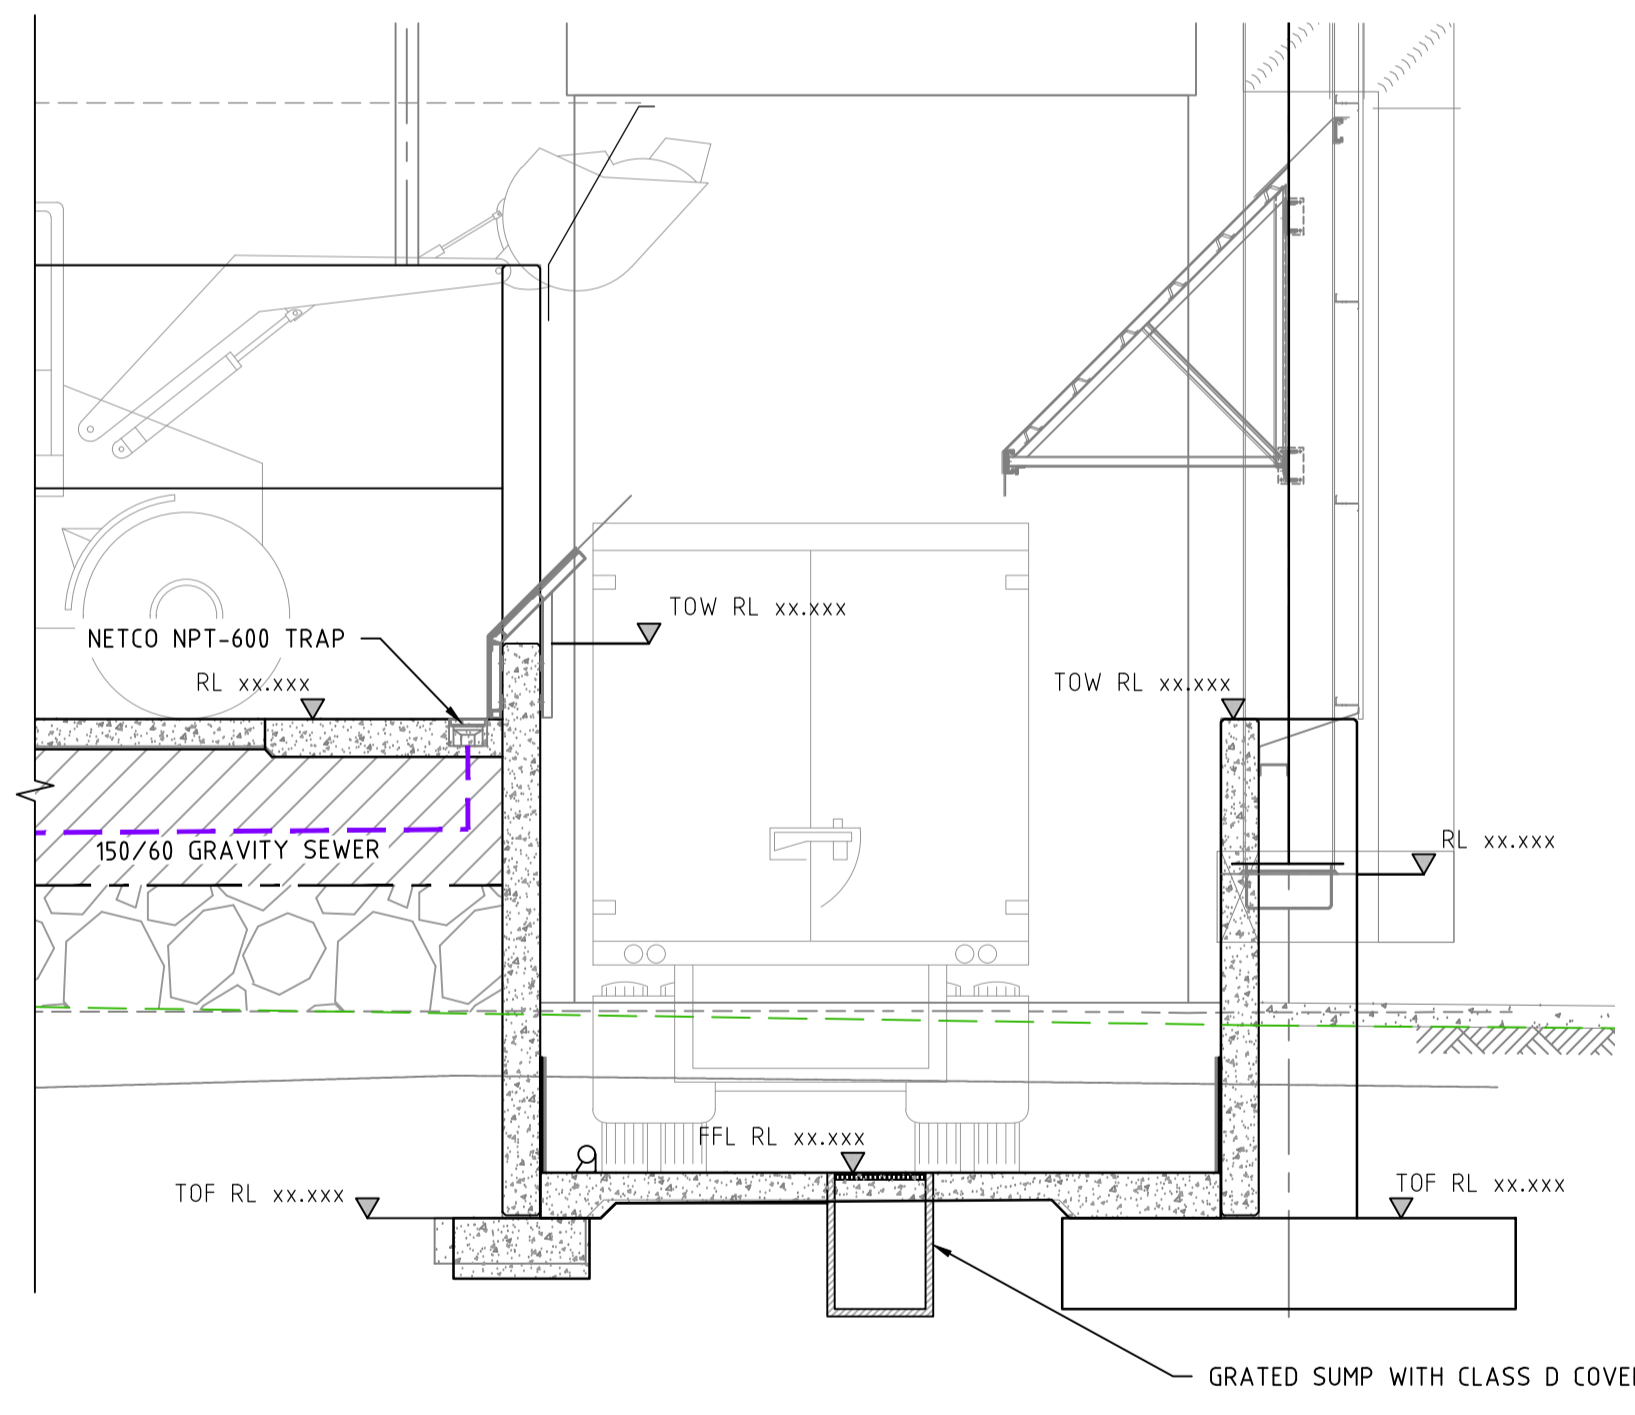

B SECTION - NETCO SILT TRAP AND PUMP
 SCALE: 1:50
 REFER TO PLAN "C-121"

FOR APPROVAL

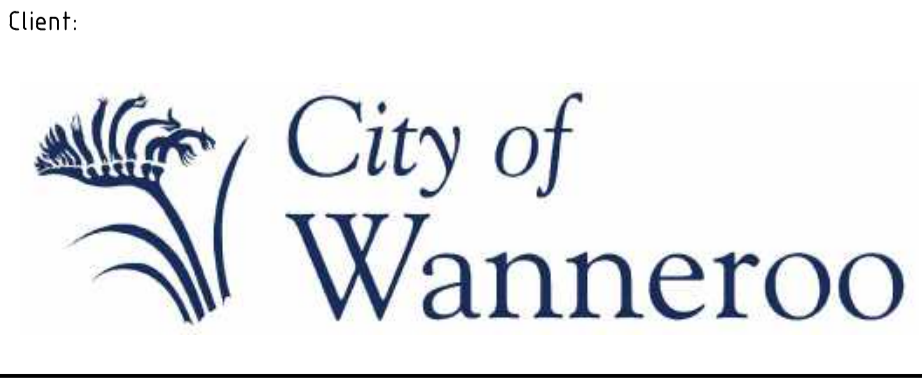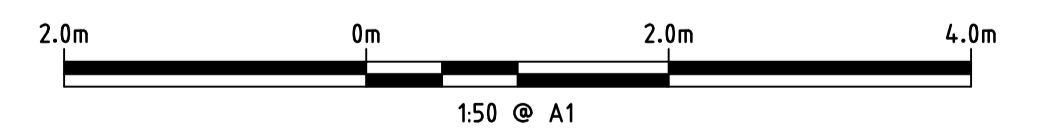

NOTES






- This drawing is the property of Talis Consultants Pty Ltd. It is a confidential document and must not be copied, used, or its contents divulged without prior written consent.
- DO NOT SCALE, use figured dimensions only, if in doubt please contact Talis Consultants.
- Parts of this drawing is intended to be IN COLOUR. Black & White Printing may cause errors or omissions. If this text is not GREEN, please contact Talis Consultants.

No.	Date	By	App.	Amendment / Issue
A	03.06.2025	YJ	AB	PRELIMINARY ISSUE

Project: **NEERABUP RRP**

Title: **TYPICAL DETAILS**


Scale: AS SHOWN @ A1	Date: 03.06.2025	
Drawn: YJ	Checked: AB	Approved:
Job No: TC25017	Drg. No: C-301	Rev: A
Filename: TC25017.DWG		

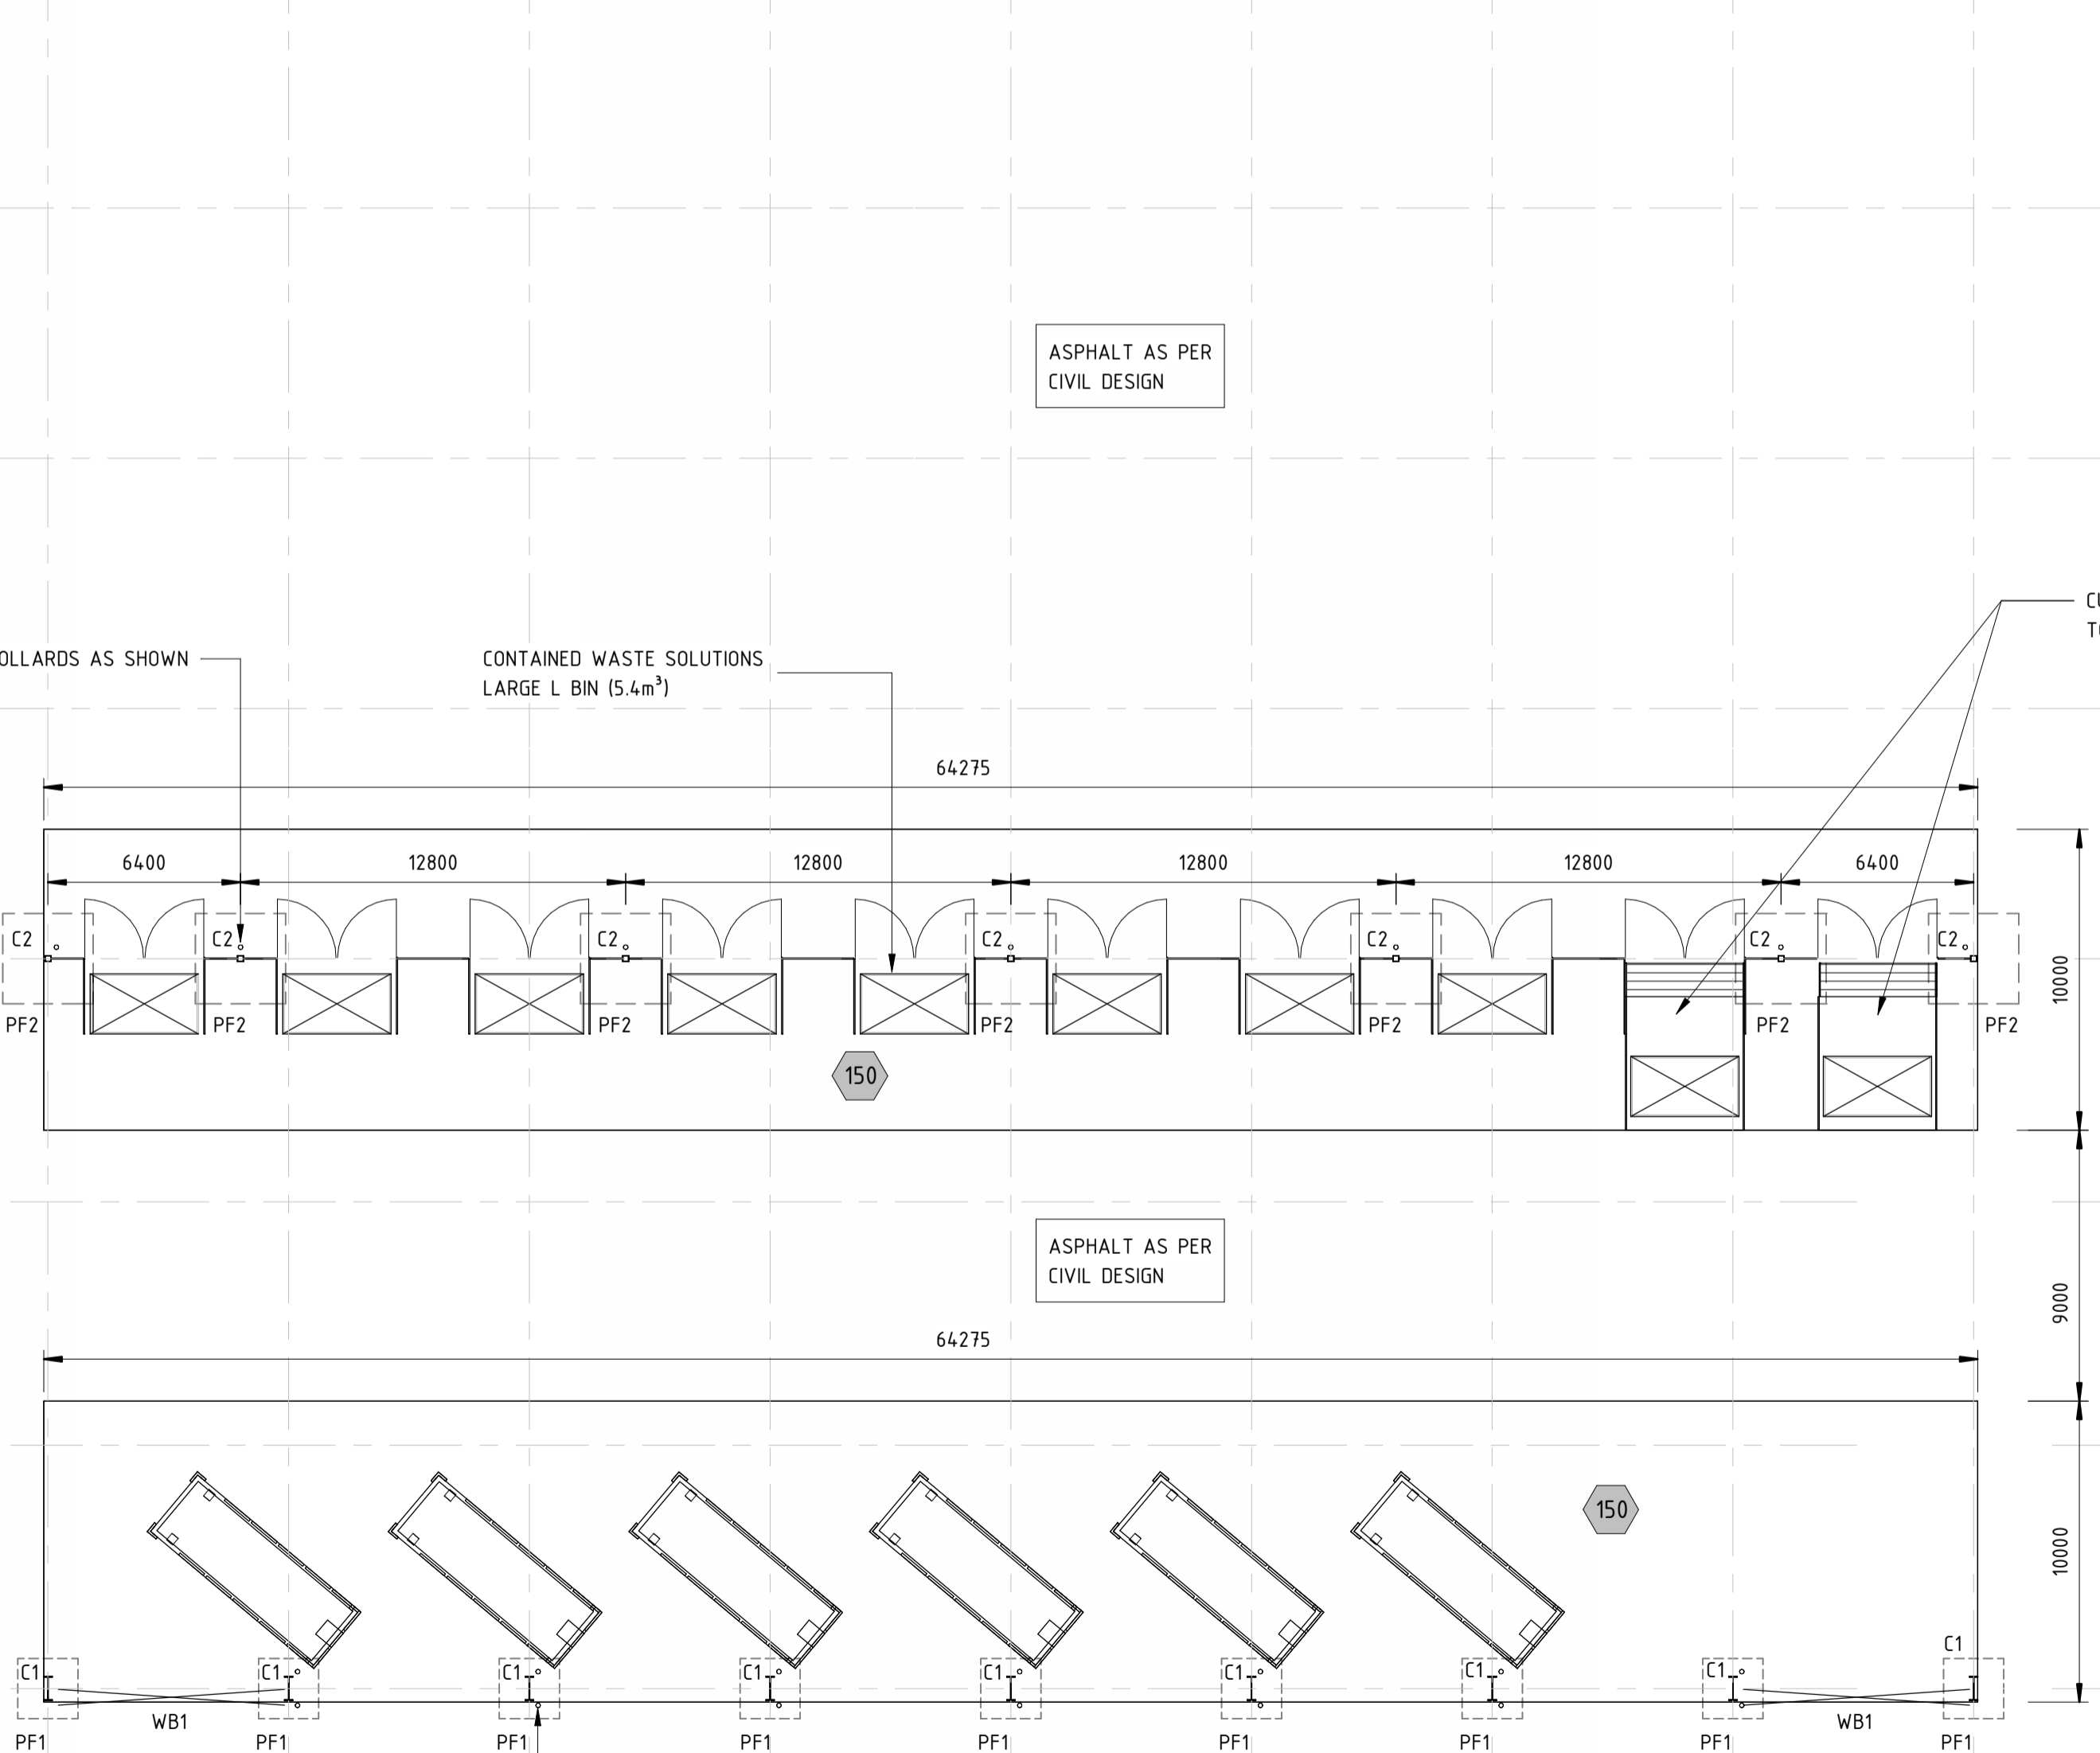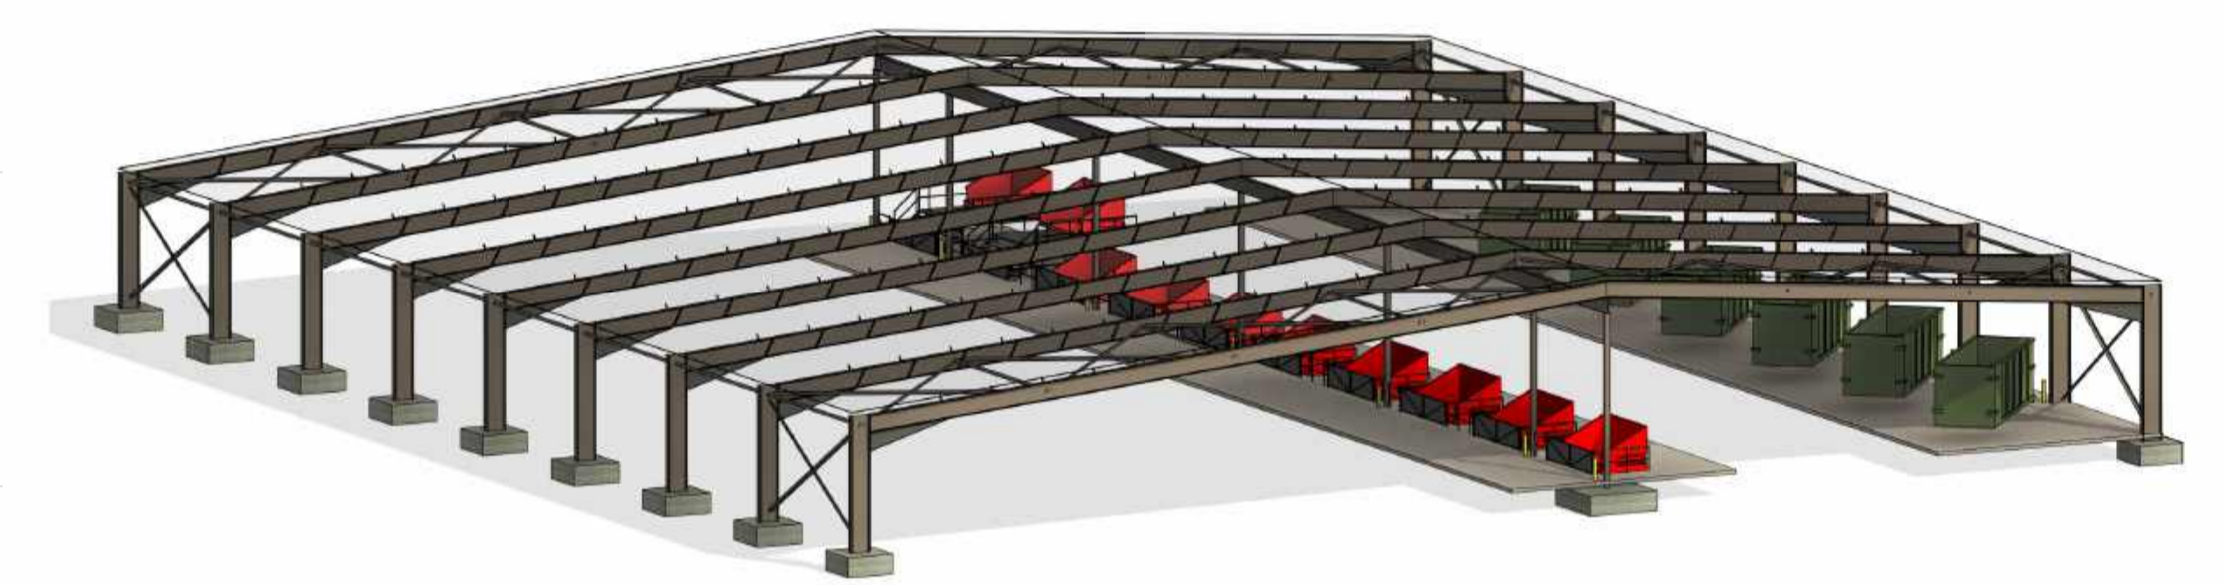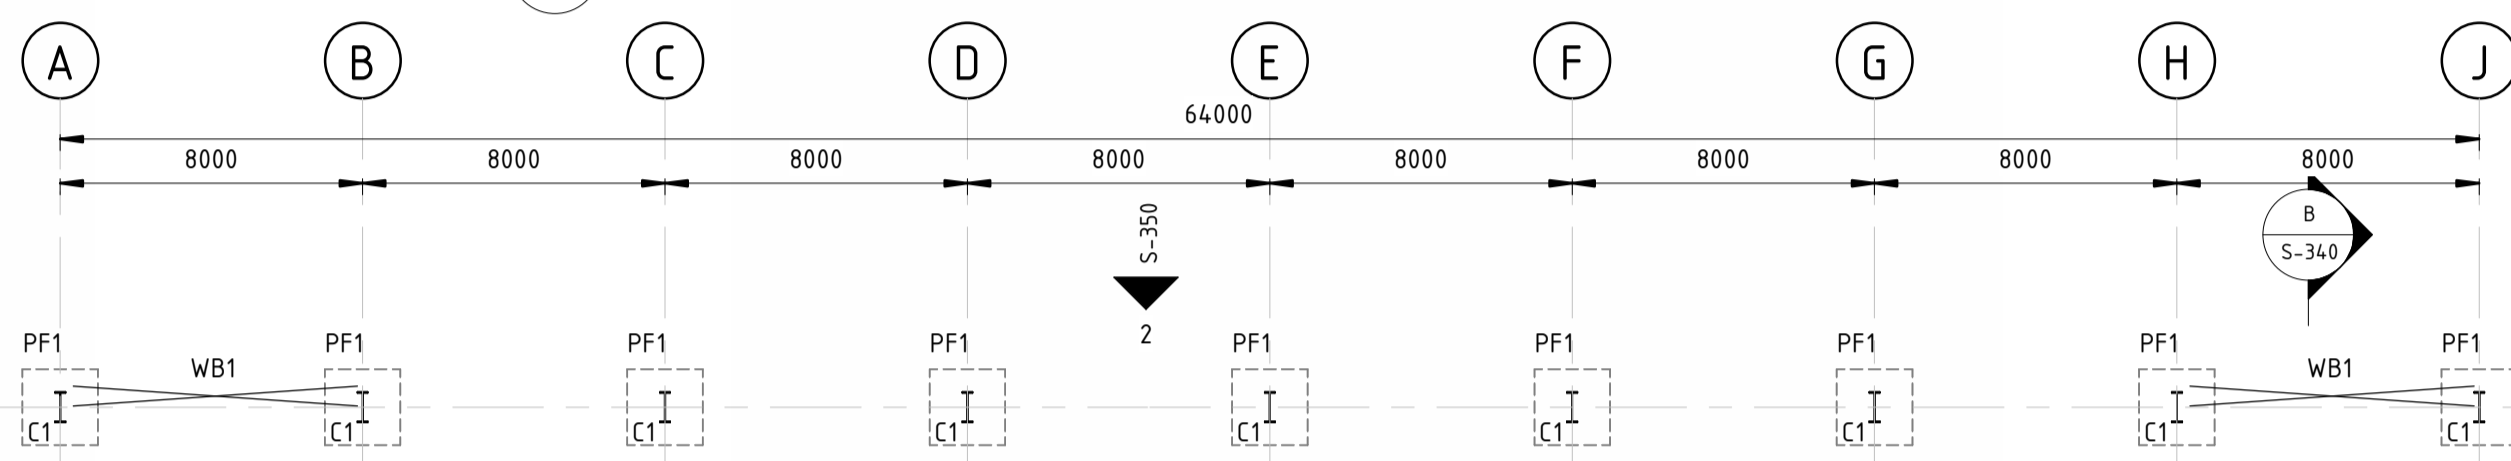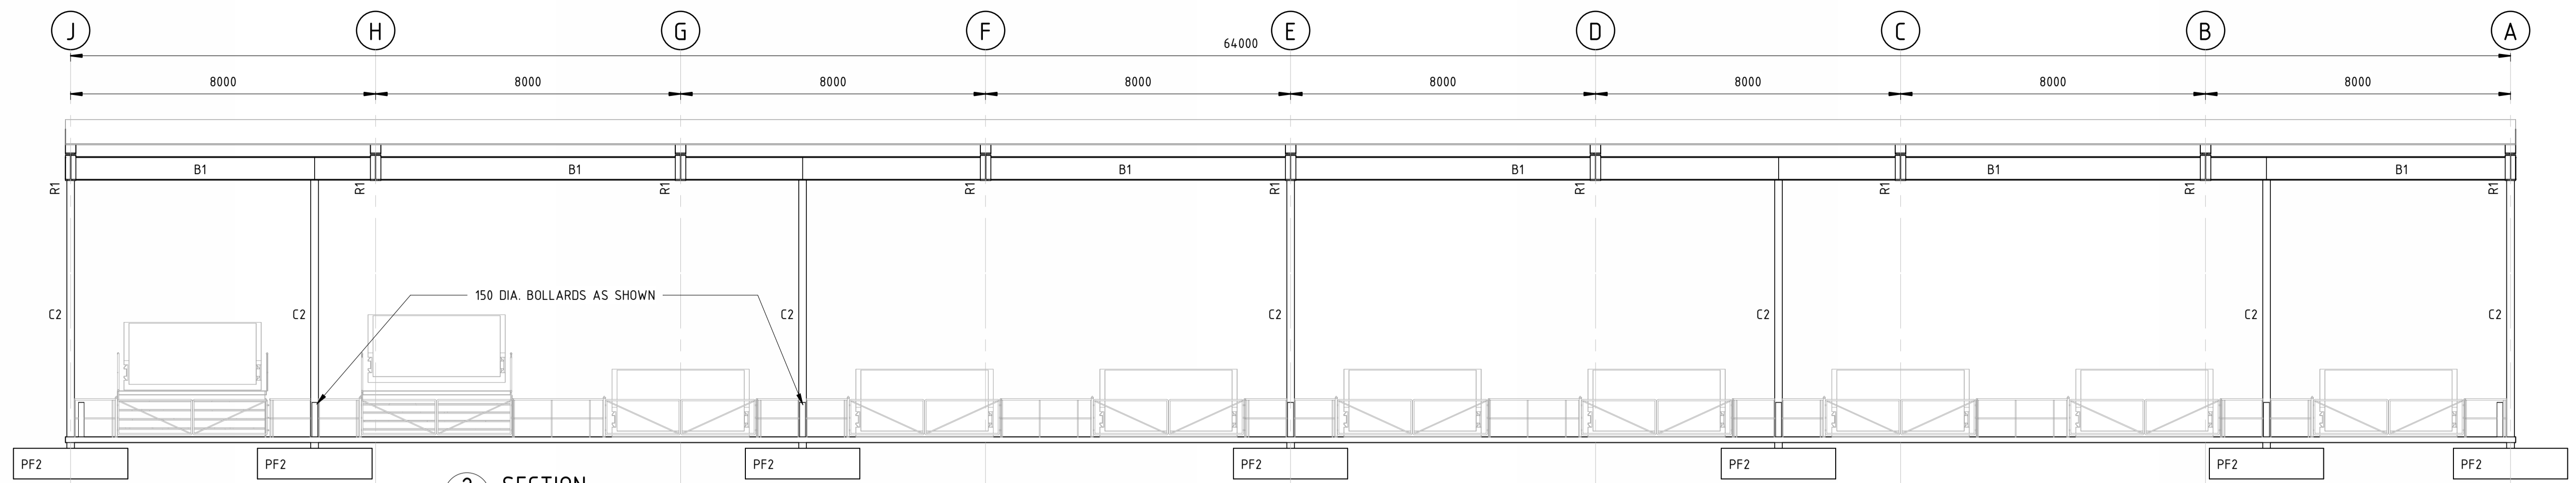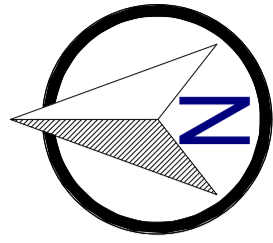

CONCEPT ONLY
NOT FOR CONSTRUCTION



1:200 @ A1

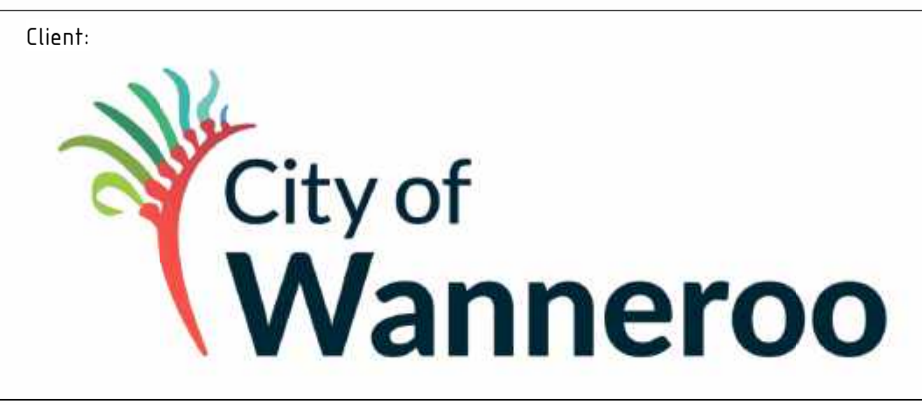




- NOTES**
1. This drawing is the property of Talis Consultants Pty Ltd. It is a confidential document and must not be copied, used, or its contents divulged without prior written consent.
 2. DO NOT SCALE, use figured dimensions only, if in doubt please contact Talis Consultants.
 3. Parts of this drawing is intended to be IN COLOUR. Black & White Printing may cause errors or omissions. If this text is not GREEN, please contact Talis Consultants

No.	Date	Dr	Ch	Amendment / Issue


Project: **NEERABUP RESOURCE RECOVERY PRECINCT - COMMUNITY RECYCLING CENTRE**

Title: **RESIDUAL WASTE DROPOFF - FLOOR PLAN AND SECTION**


Scale: AS SHOWN	Date: 30.01.2026	
Drawn: CON	Checked: SM	Approved: SM
Job No: TC25017	Drg. No: S-000	REV:
Filename: T:\SECTIONS\Engineering\Projects\TC2025\TC25015 - NRRP Concept Design\Drawings\8_Revit\TC25017 - NRRP Residual Waste Drop off.rvt		

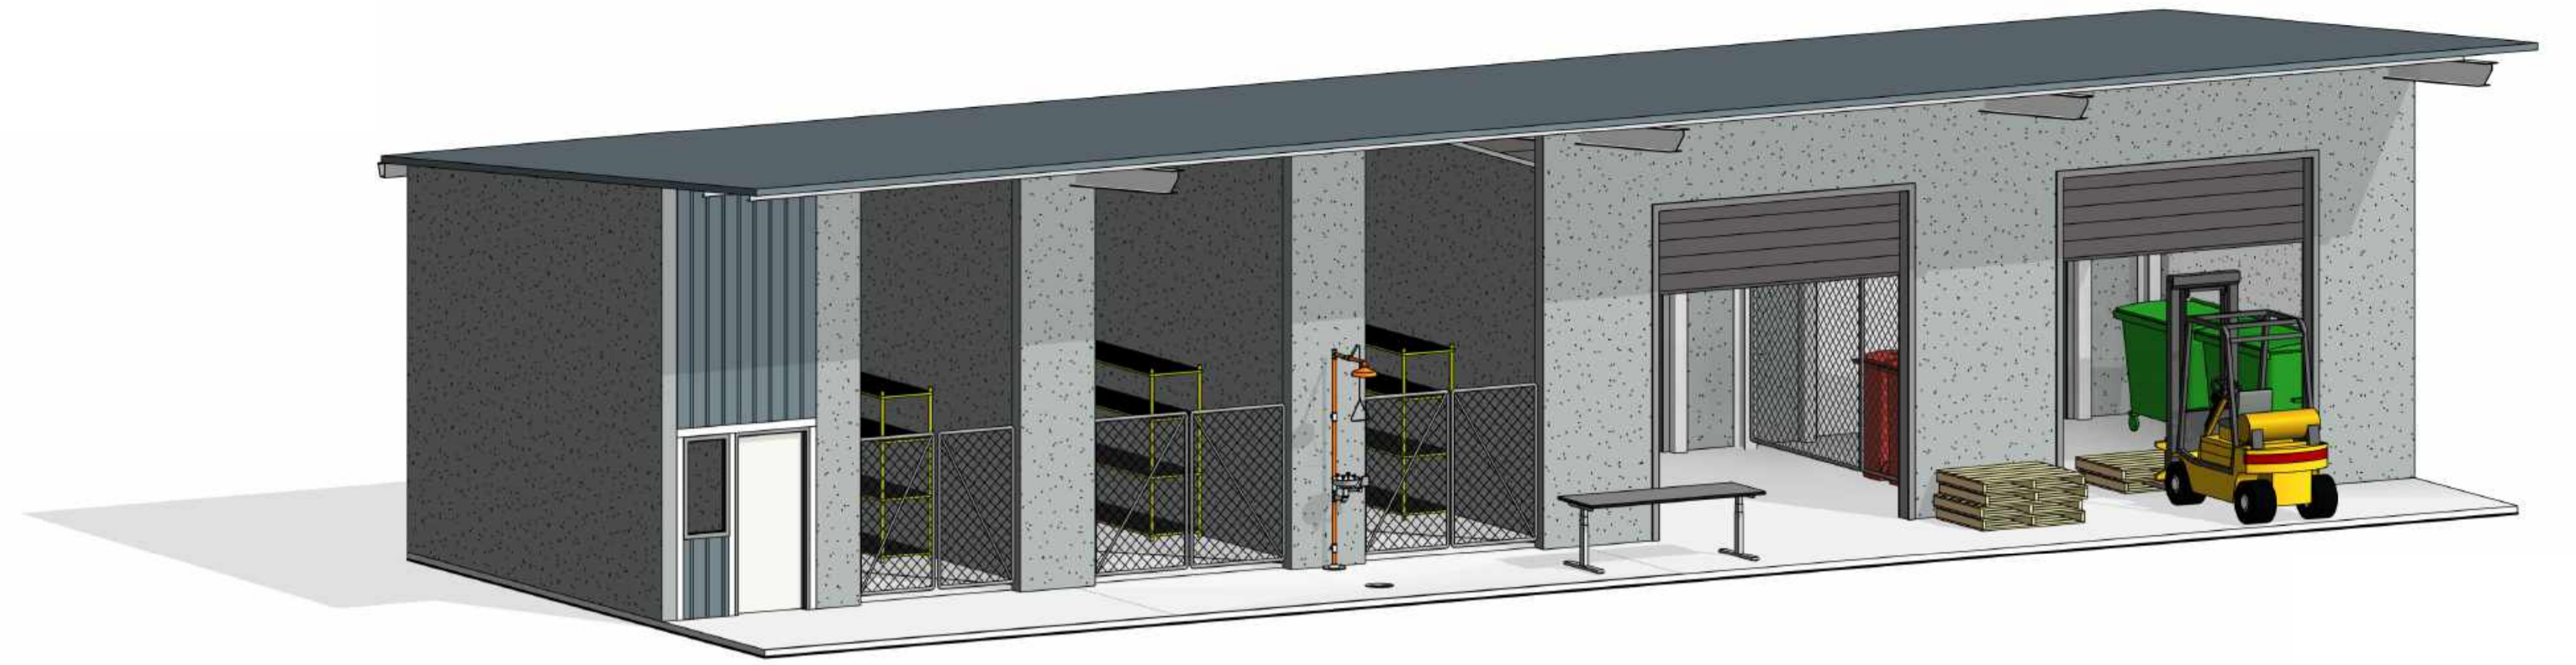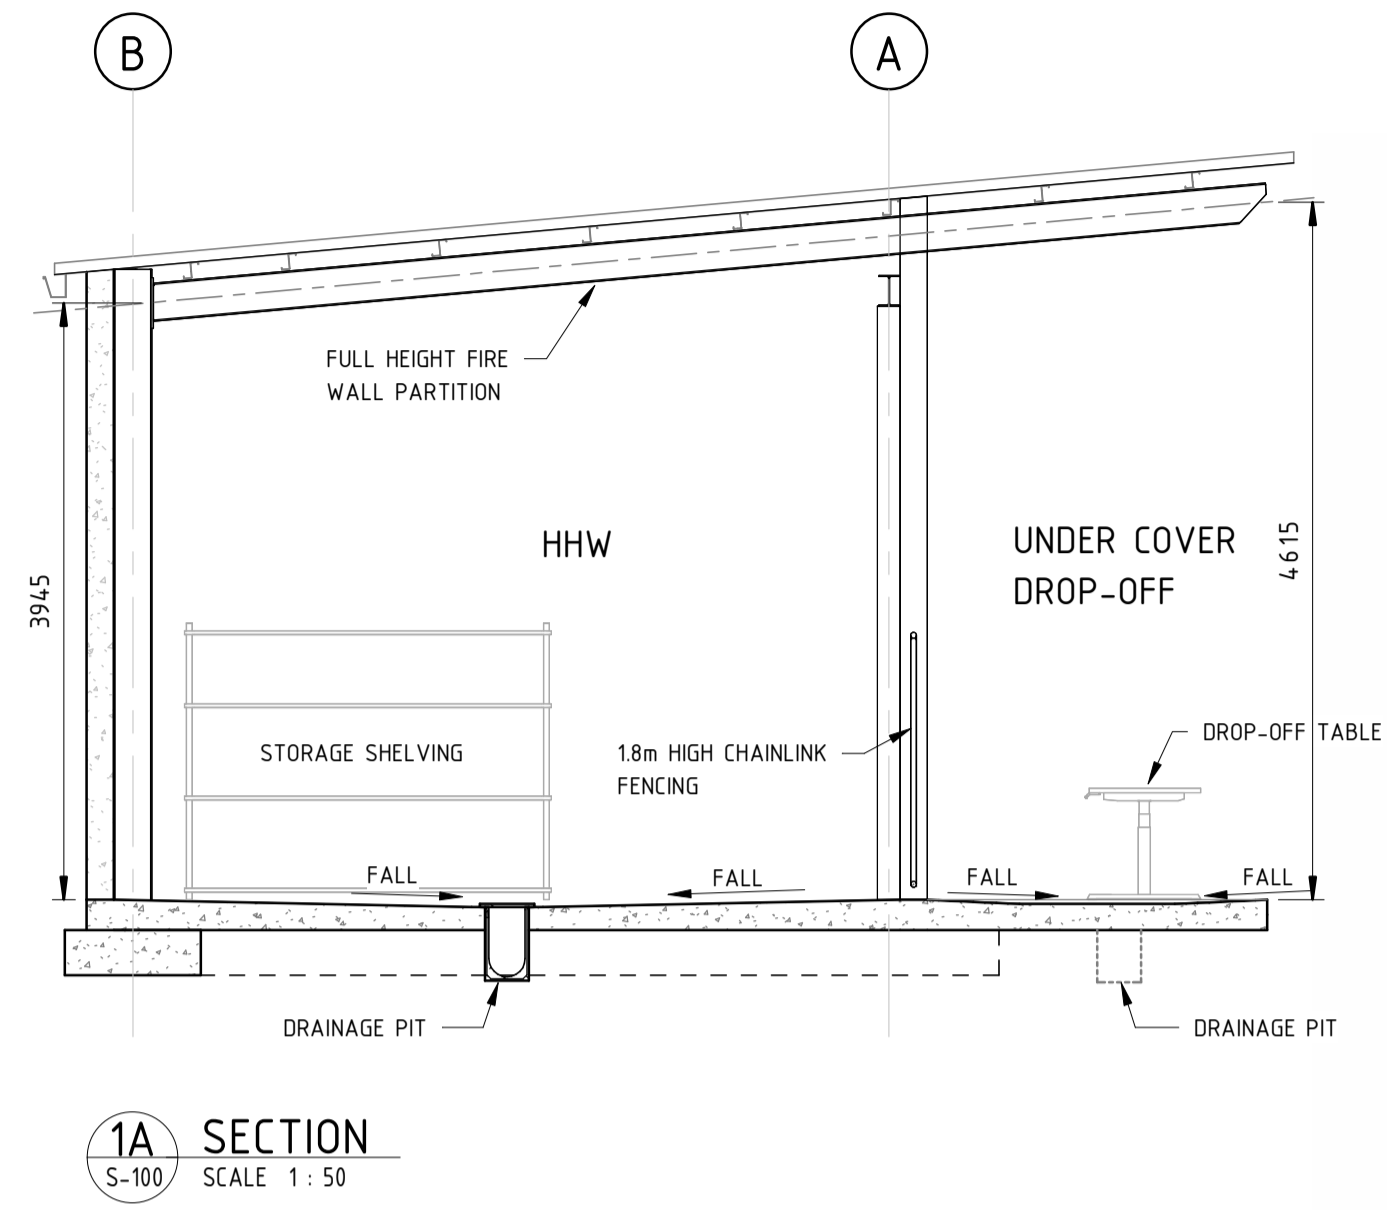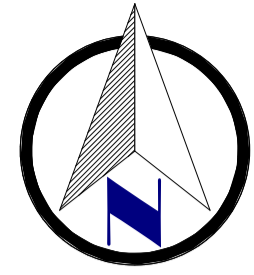


ISOMETRIC

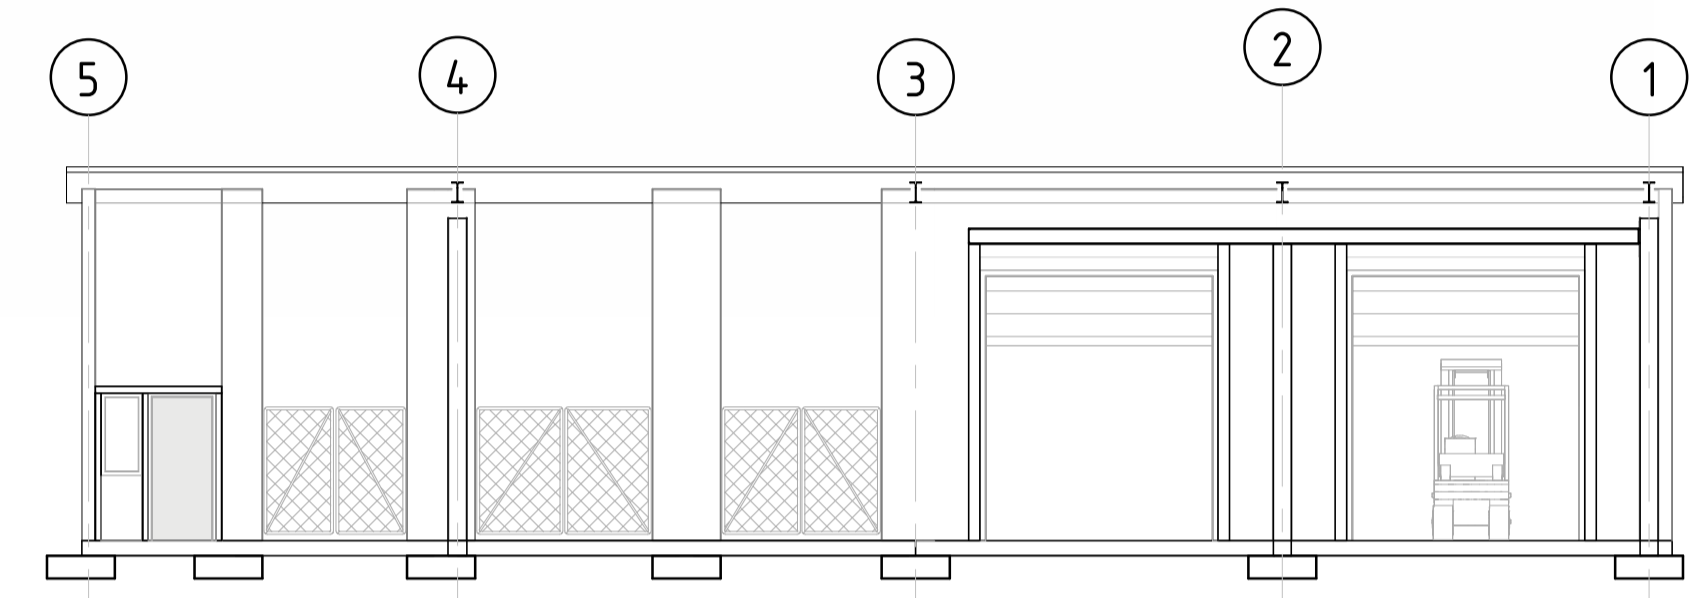


NORTH ELEVATION
1 : 100

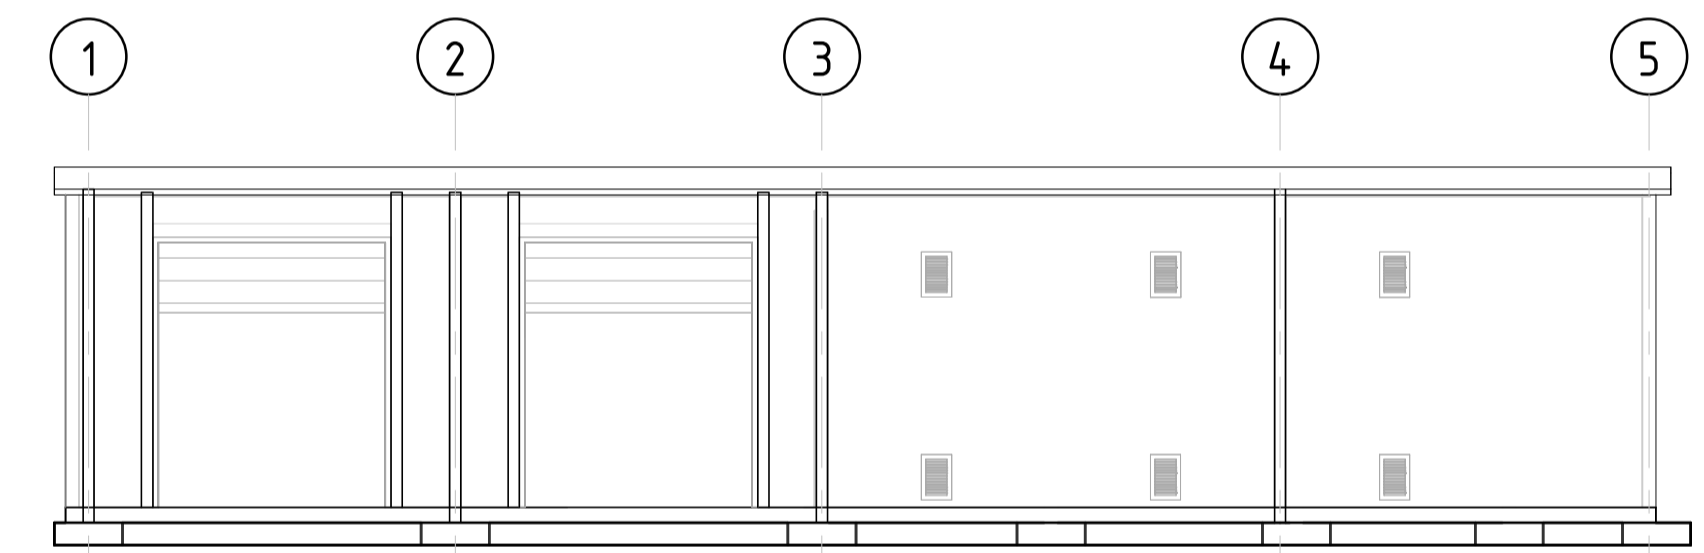


SOUTH ELEVATION
1 : 100

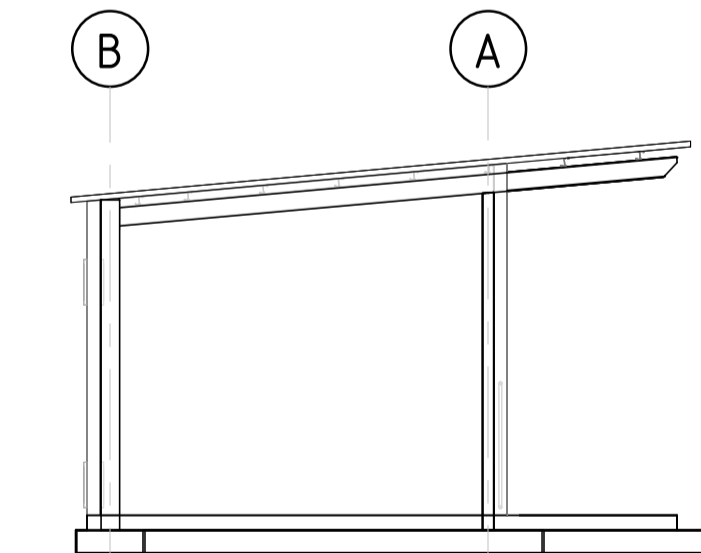

EAST ELEVATION
1 : 100

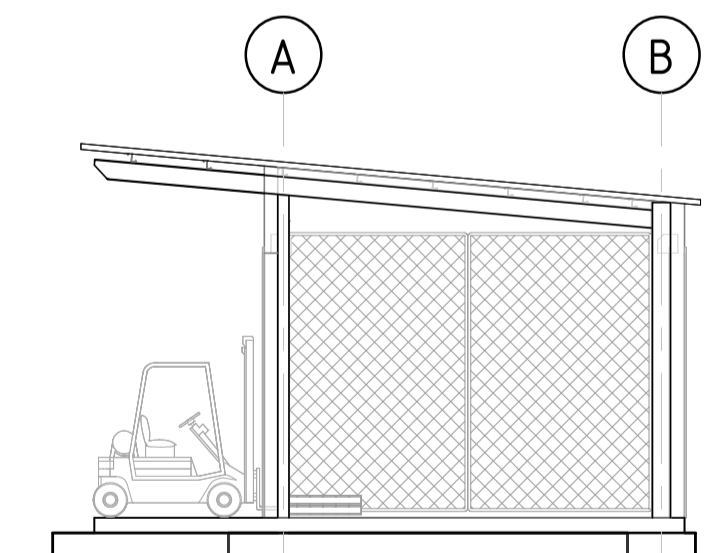

WEST ELEVATION
1 : 100

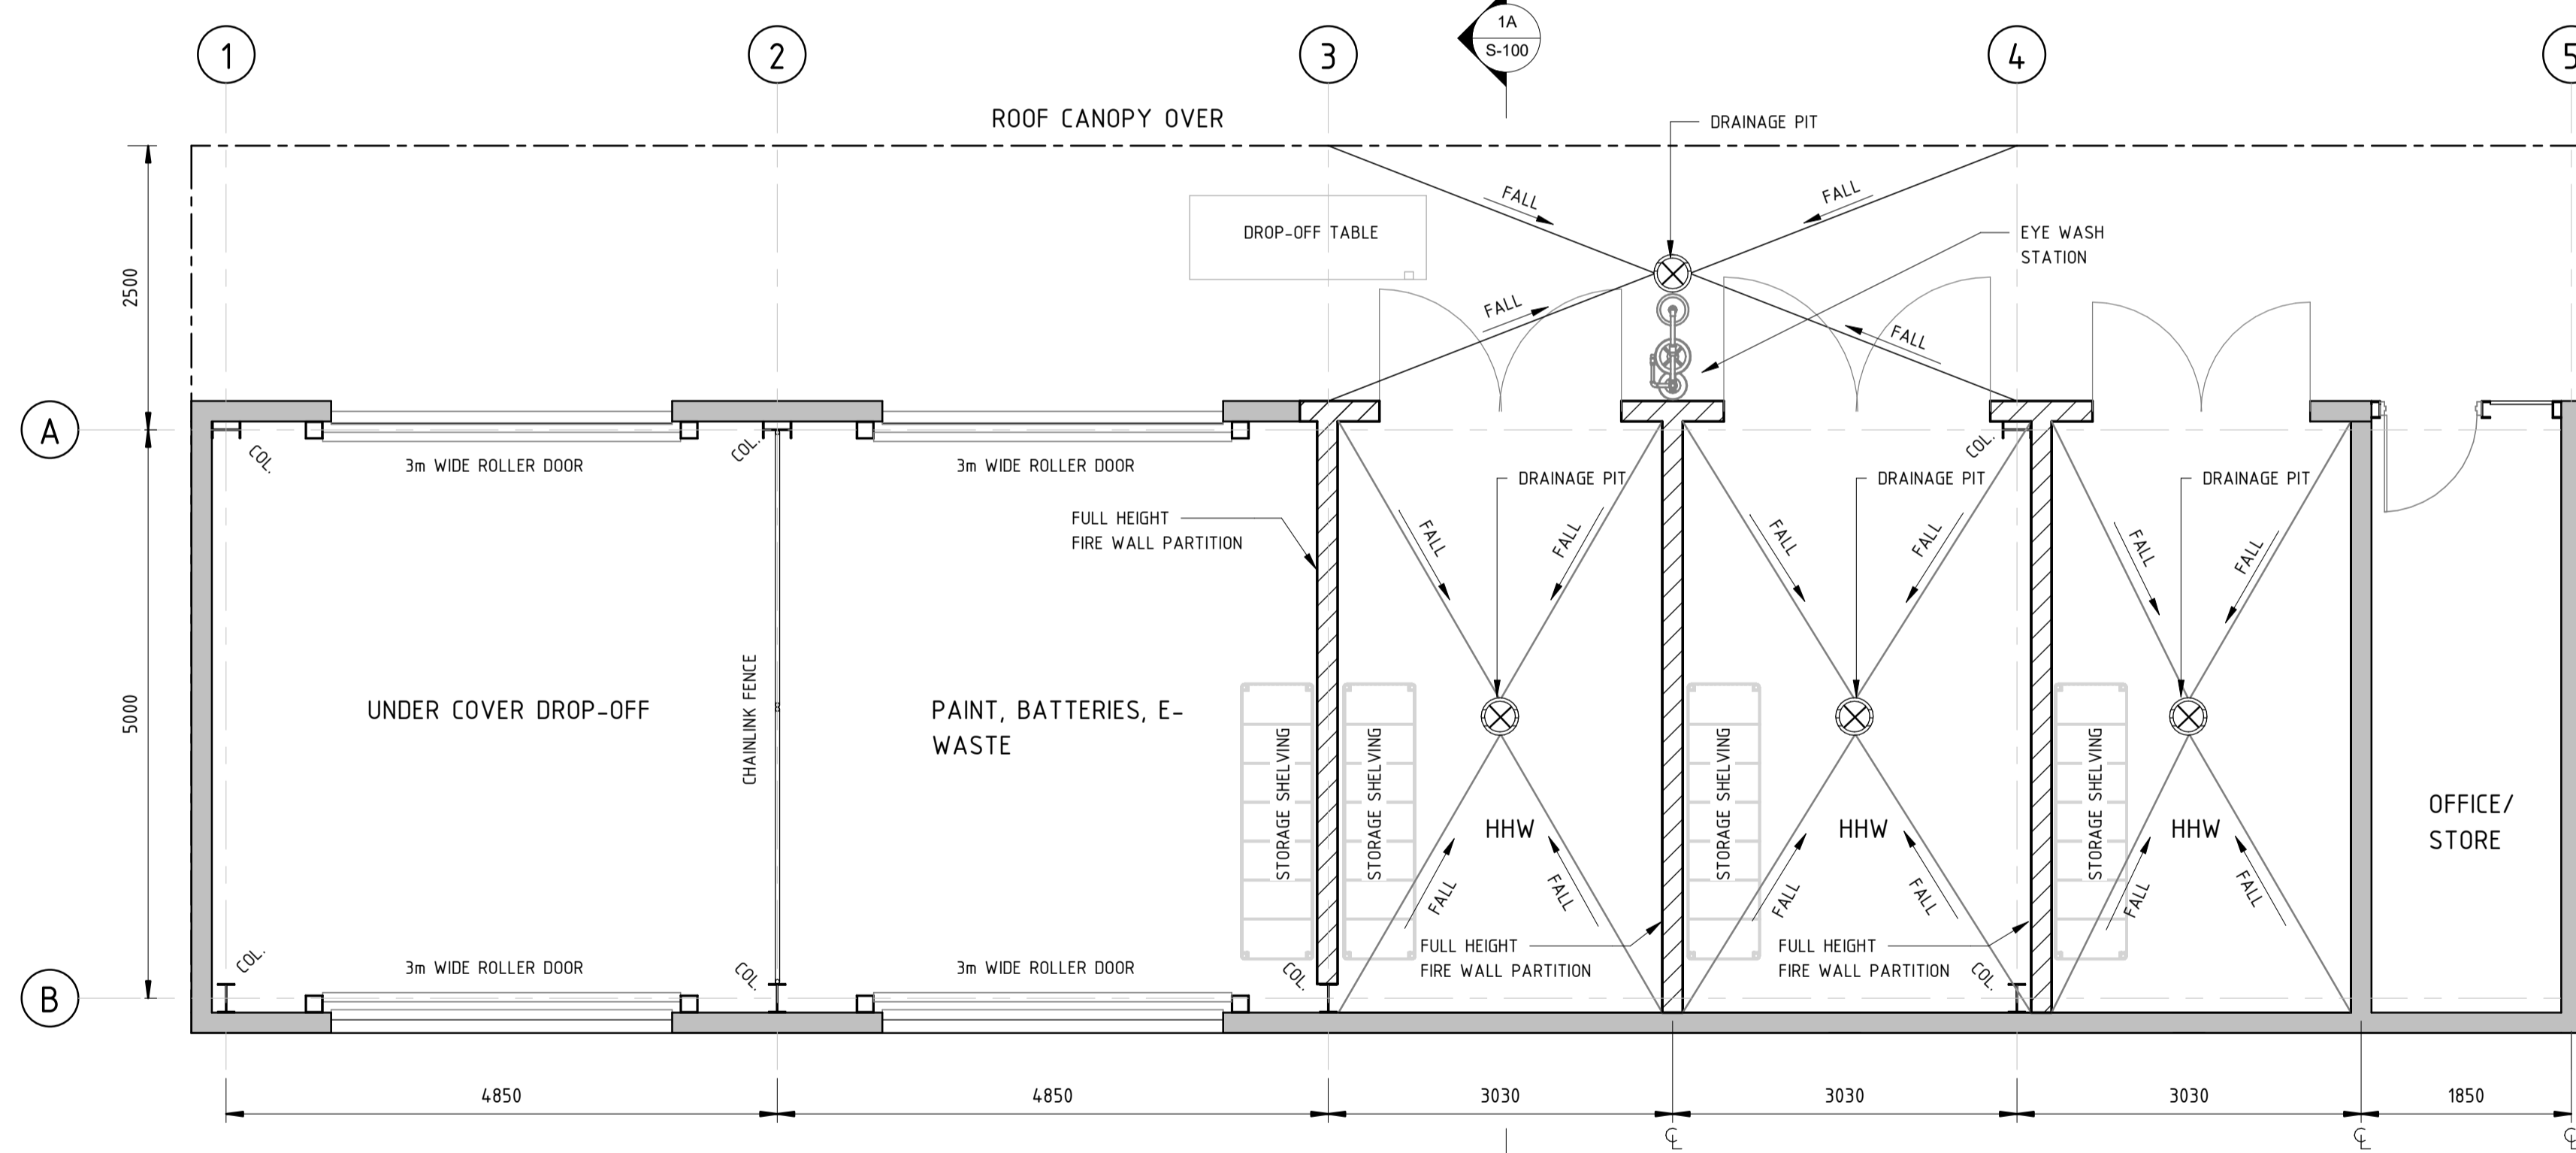


FLOOR LAYOUT
1 : 50

PRELIMINARY ONLY
NOT FOR CONSTRUCTION



1:100 @ A1

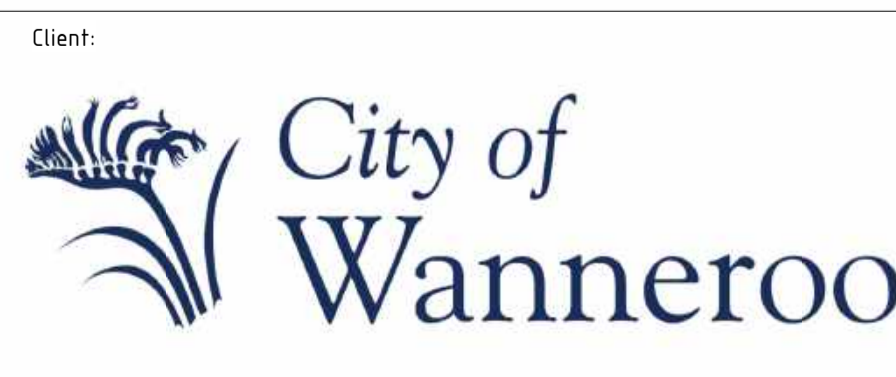

NOTES


1. This drawing is the property of Talis Consultants Pty Ltd. It is a confidential document and must not be copied, used, or its contents divulged without prior written consent.
2. DO NOT SCALE, use figured dimensions only, if in doubt please contact Talis Consultants.
3. Parts of this drawing is intended to be IN COLOUR. Black & White Printing may cause errors or omissions. If this text is not GREEN, please contact Talis Consultants

No.	Date	Dr	Ch	Amendment / Issue


Project: **NEERABUP RRP**

Title: **HHW LAYOUT**


Scale: AS SHOWN	Date: 20/06/25	
Drawn: CON	Checked: SM	Approved:
Job No: TC25017	Drg. No: S-100	REV:
Filename: Y:\SECTIONS\Engineering\Projects\TC2025\TC25015 - NRRP Concept Design\Drawings\8_Revit\TC25017 - NRRP HHW Model.rvt		

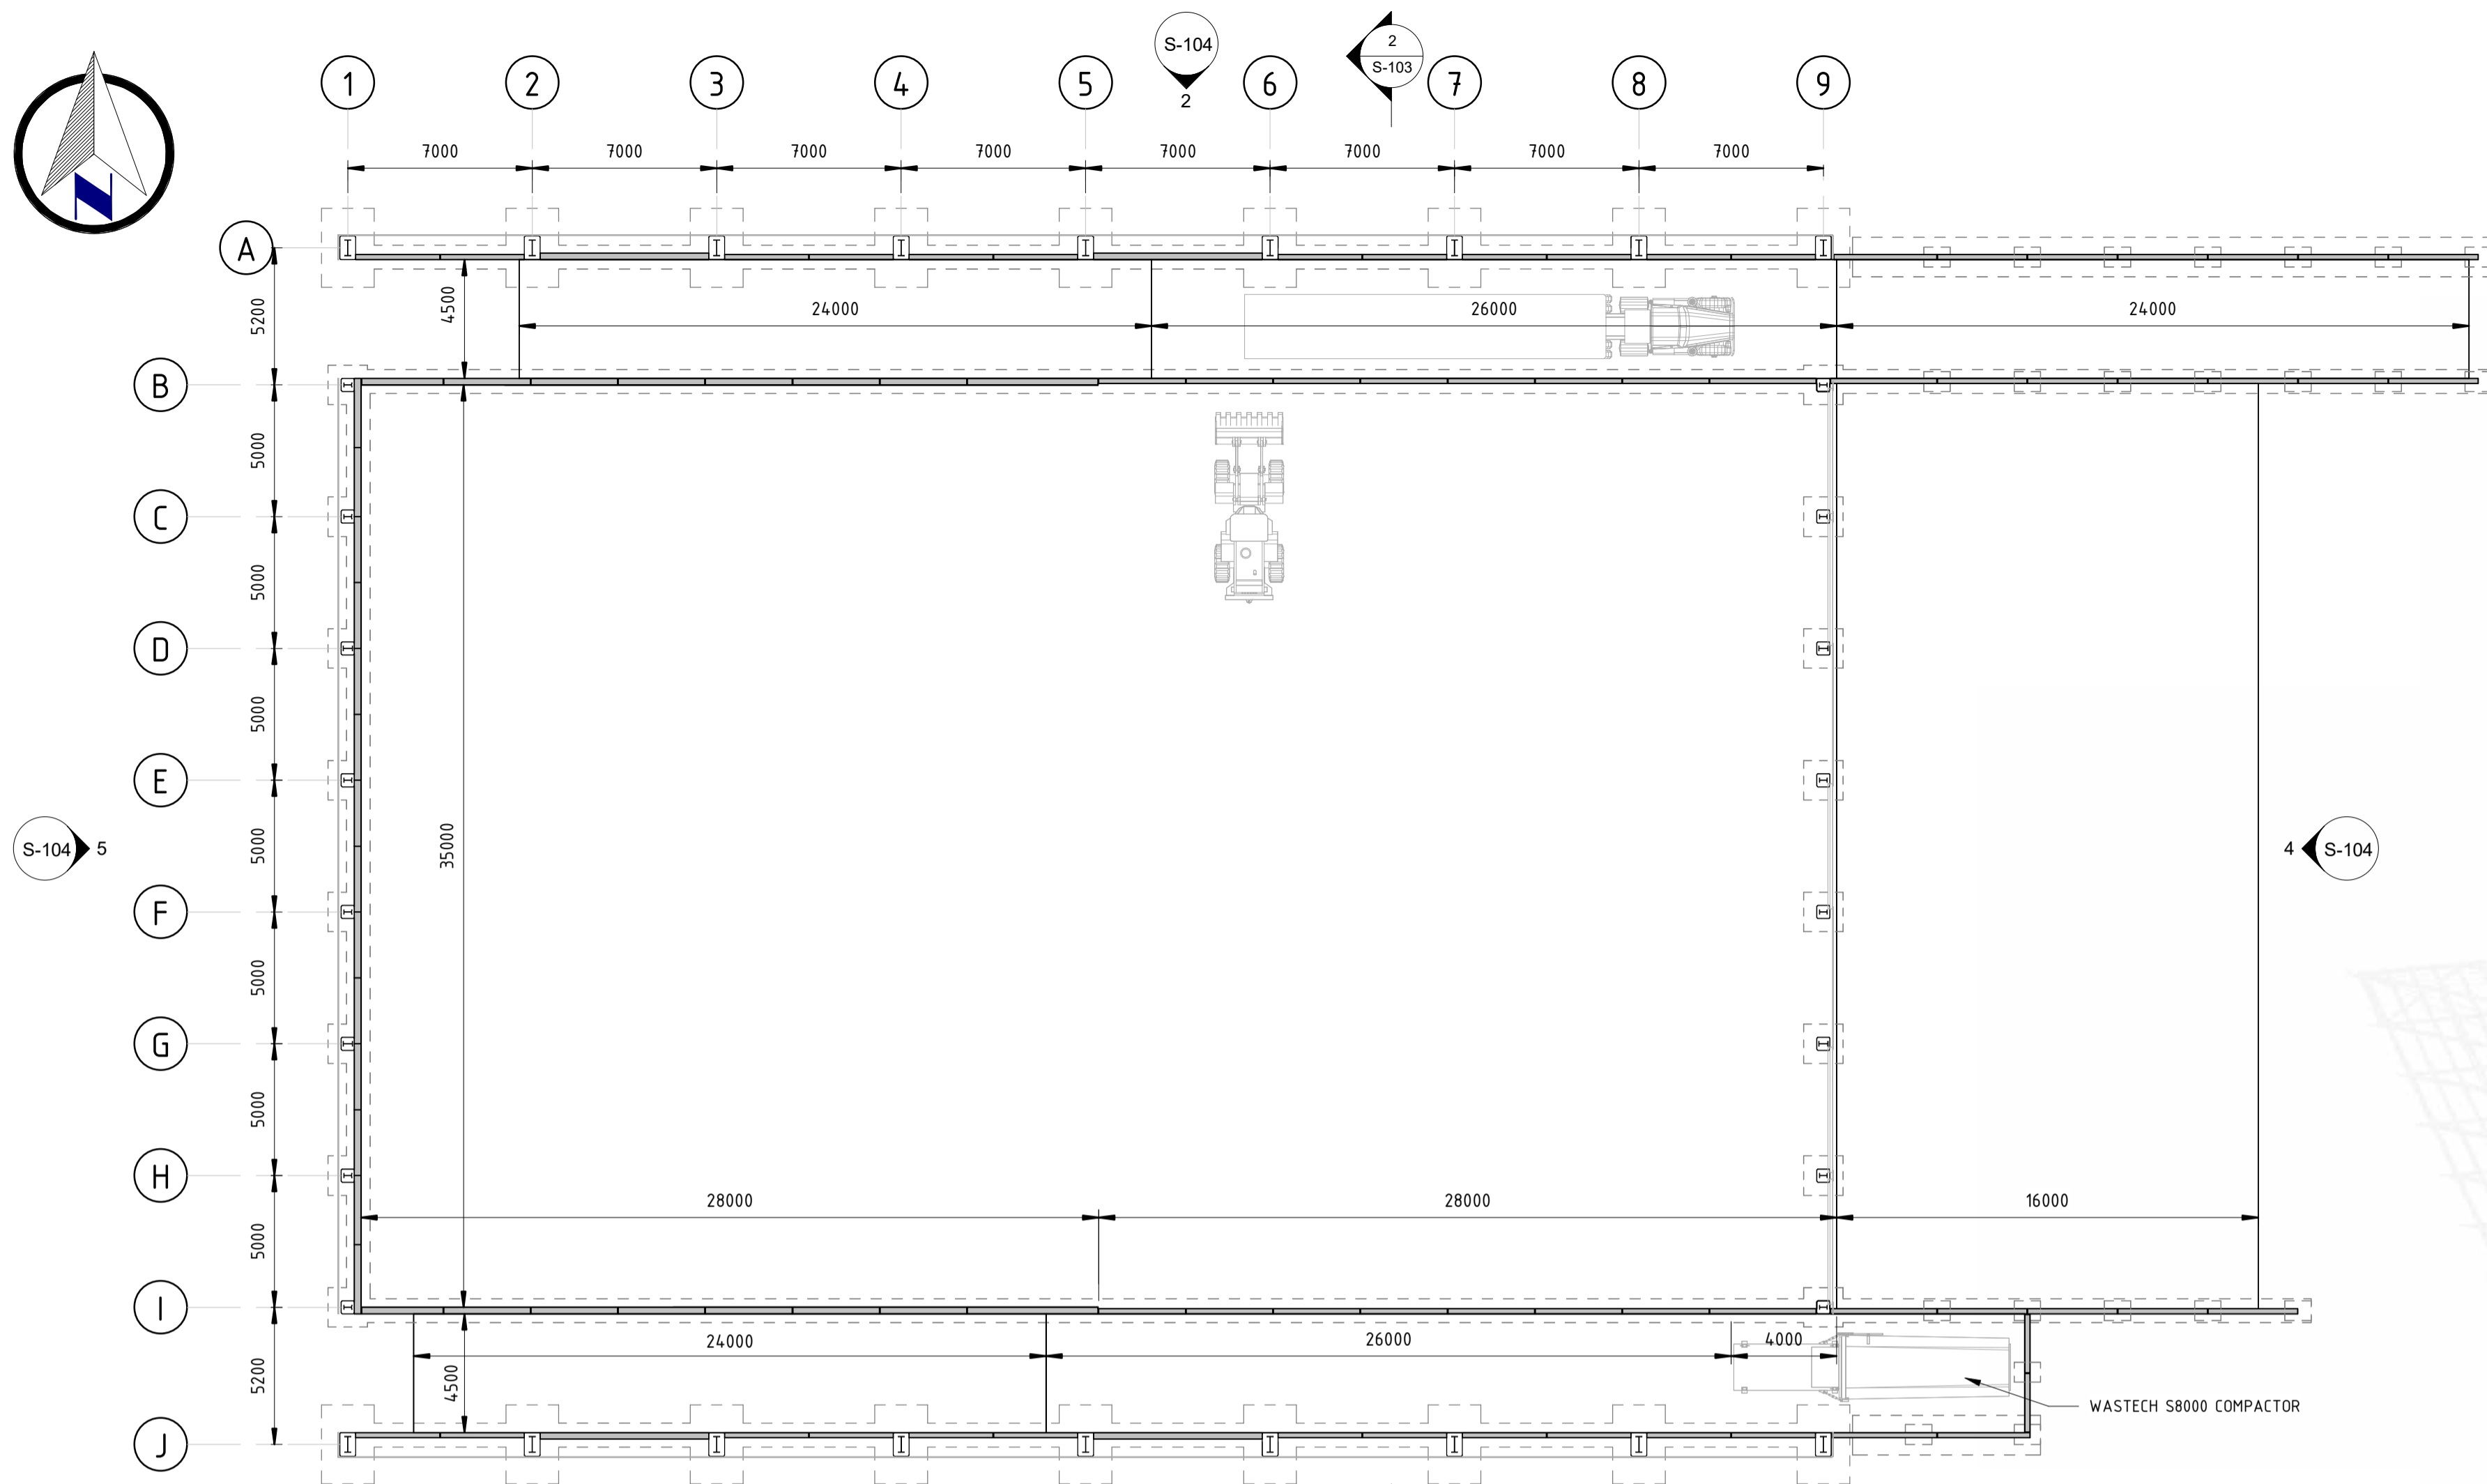

GROUND SLAB LAYOUT
1 : 200

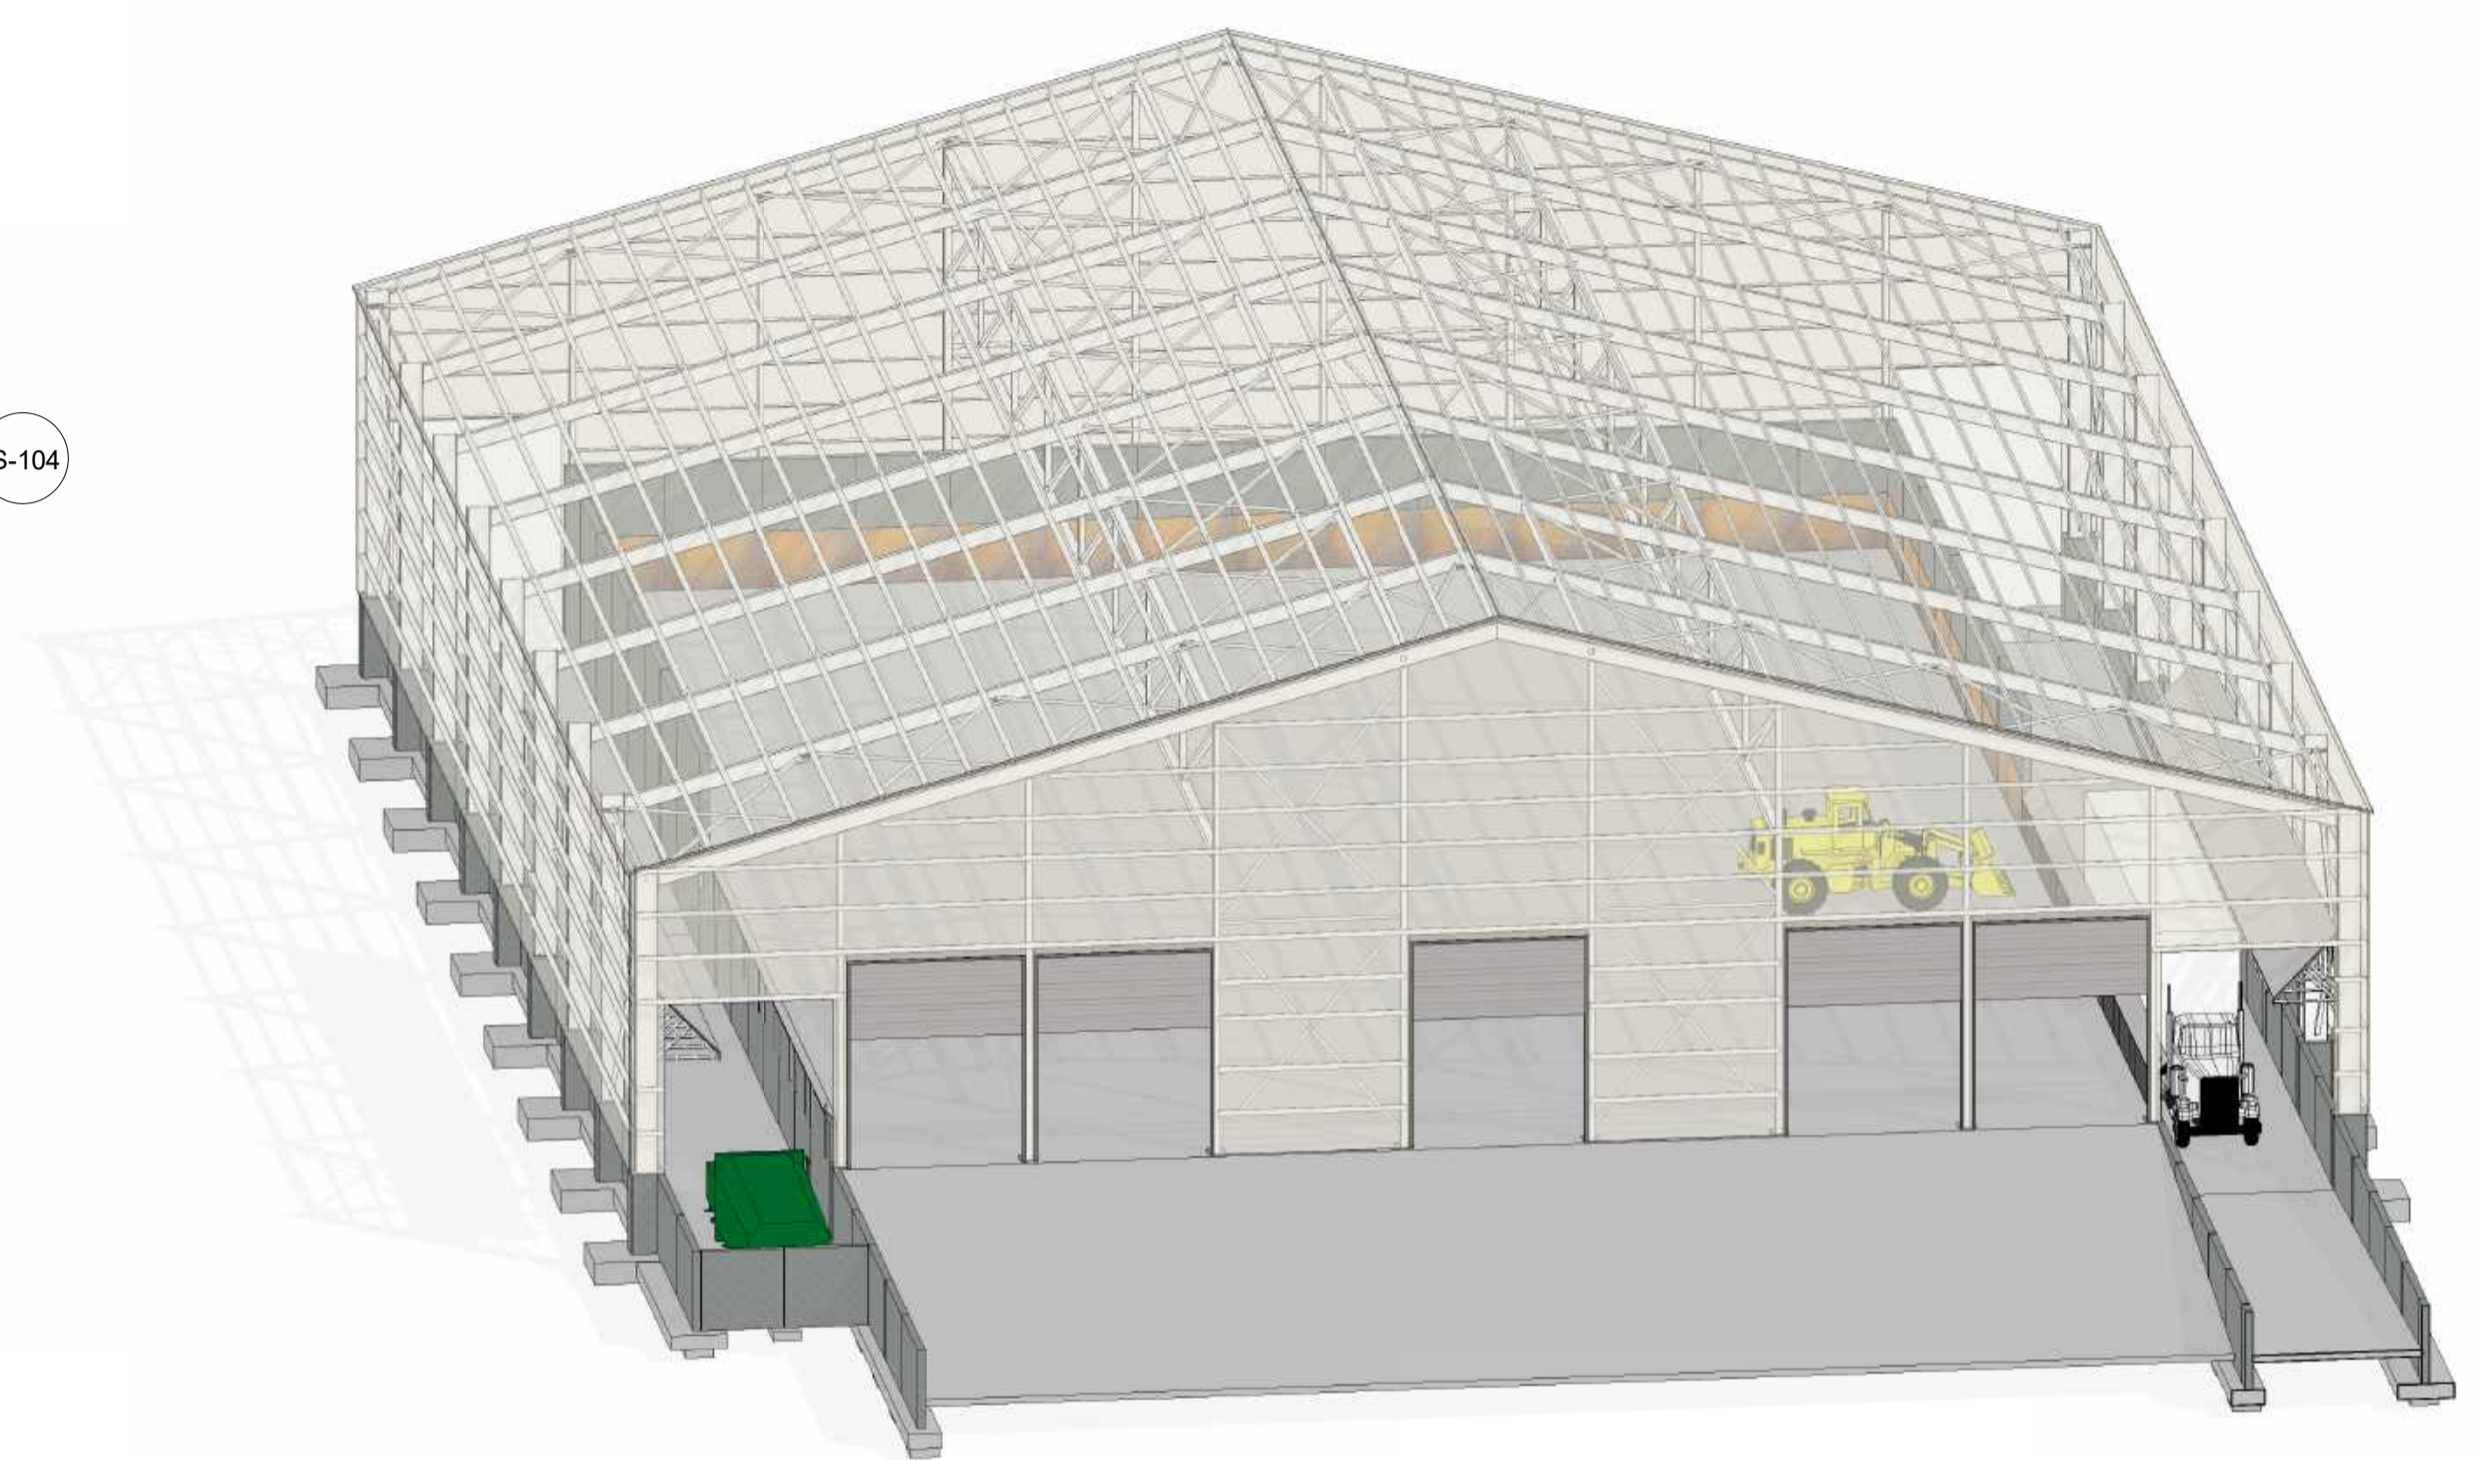

ISOMETRIC

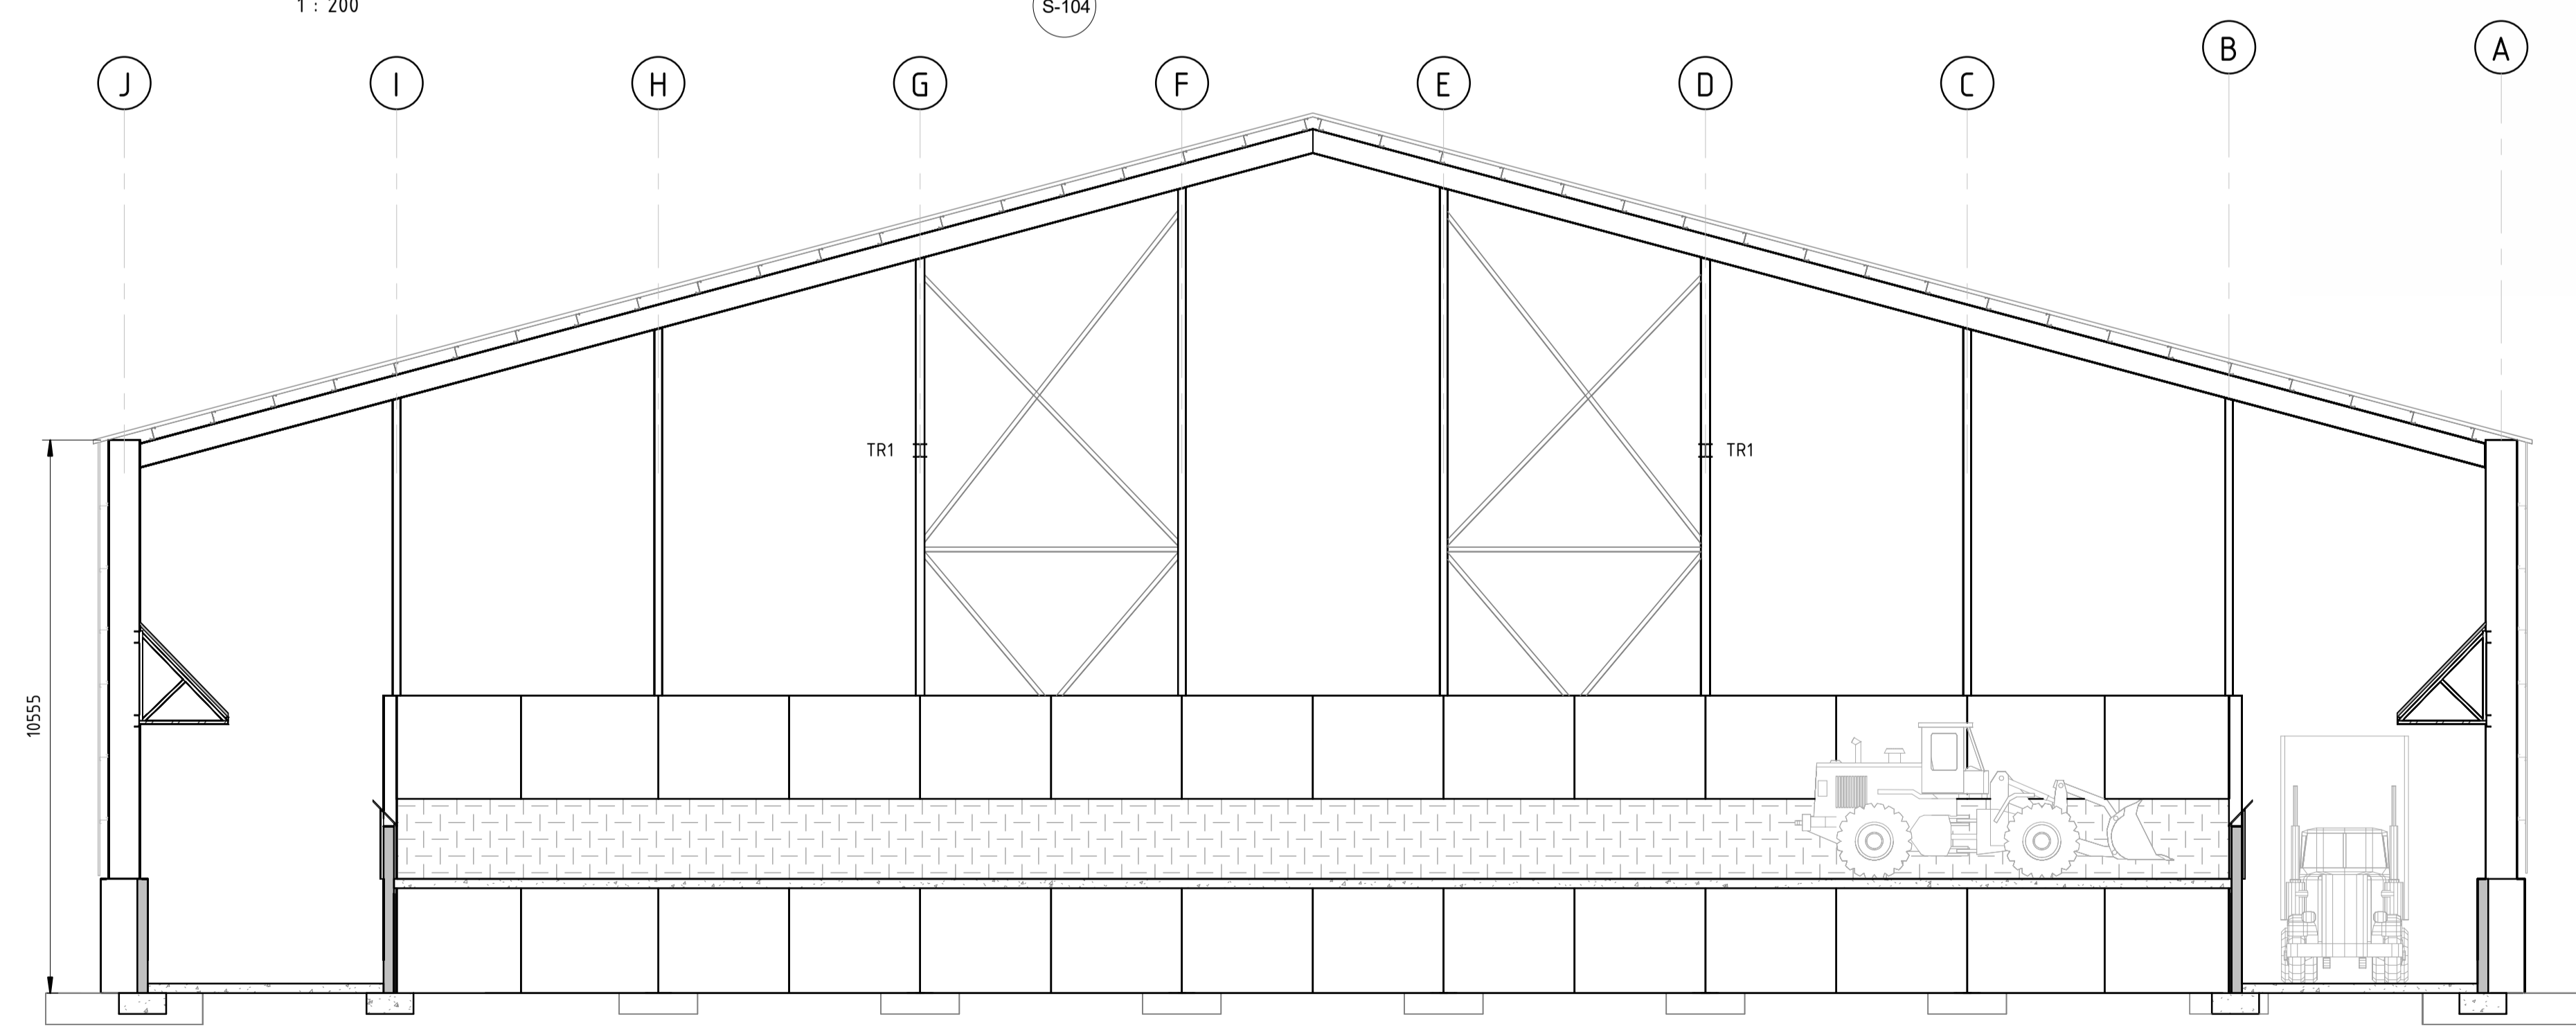


2 SECTION
S-103 SCALE 1 : 100



1:100 @ A1

PRELIMINARY ONLY
NOT FOR CONSTRUCTION

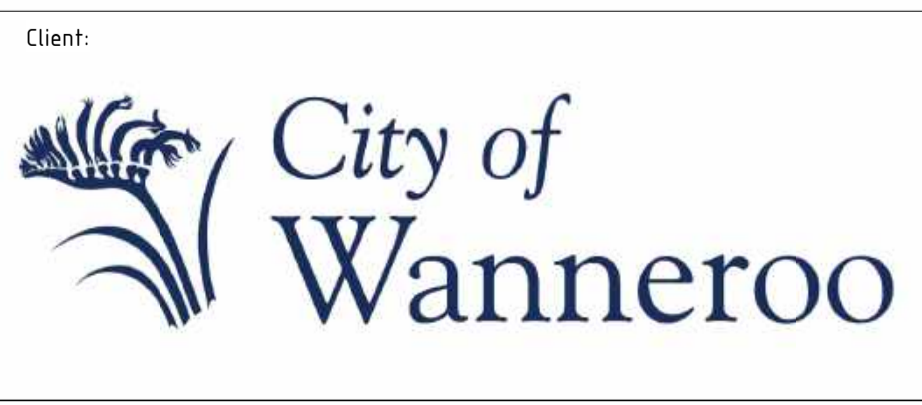

NOTES


- This drawing is the property of Talis Consultants Pty Ltd. It is a confidential document and must not be copied, used, or its contents divulged without prior written consent.
- DO NOT SCALE, use figured dimensions only, if in doubt please contact Talis Consultants.
- Parts of this drawing is intended to be IN COLOUR. Black & White Printing may cause errors or omissions. If this text is not GREEN, please contact Talis Consultants

No.	Date	Dr	Ch	Amendment / Issue


Project: NEERABUP RRP

Title: FLOOR PLAN AND SECTION DRAWINGS


Scale: AS SHOWN	Date: 04/04/25	
Drawn: CON	Checked: SM	Approved:
Job No: TC25017	Dr. No: S-103	REV:
Filename: Y:\SECTIONS\Engineering\Projects\TC2025\TC25015 - NRRP Concept Design\Drawings\8_Revit\TC25017 - NRRP WTS Model.rvt		

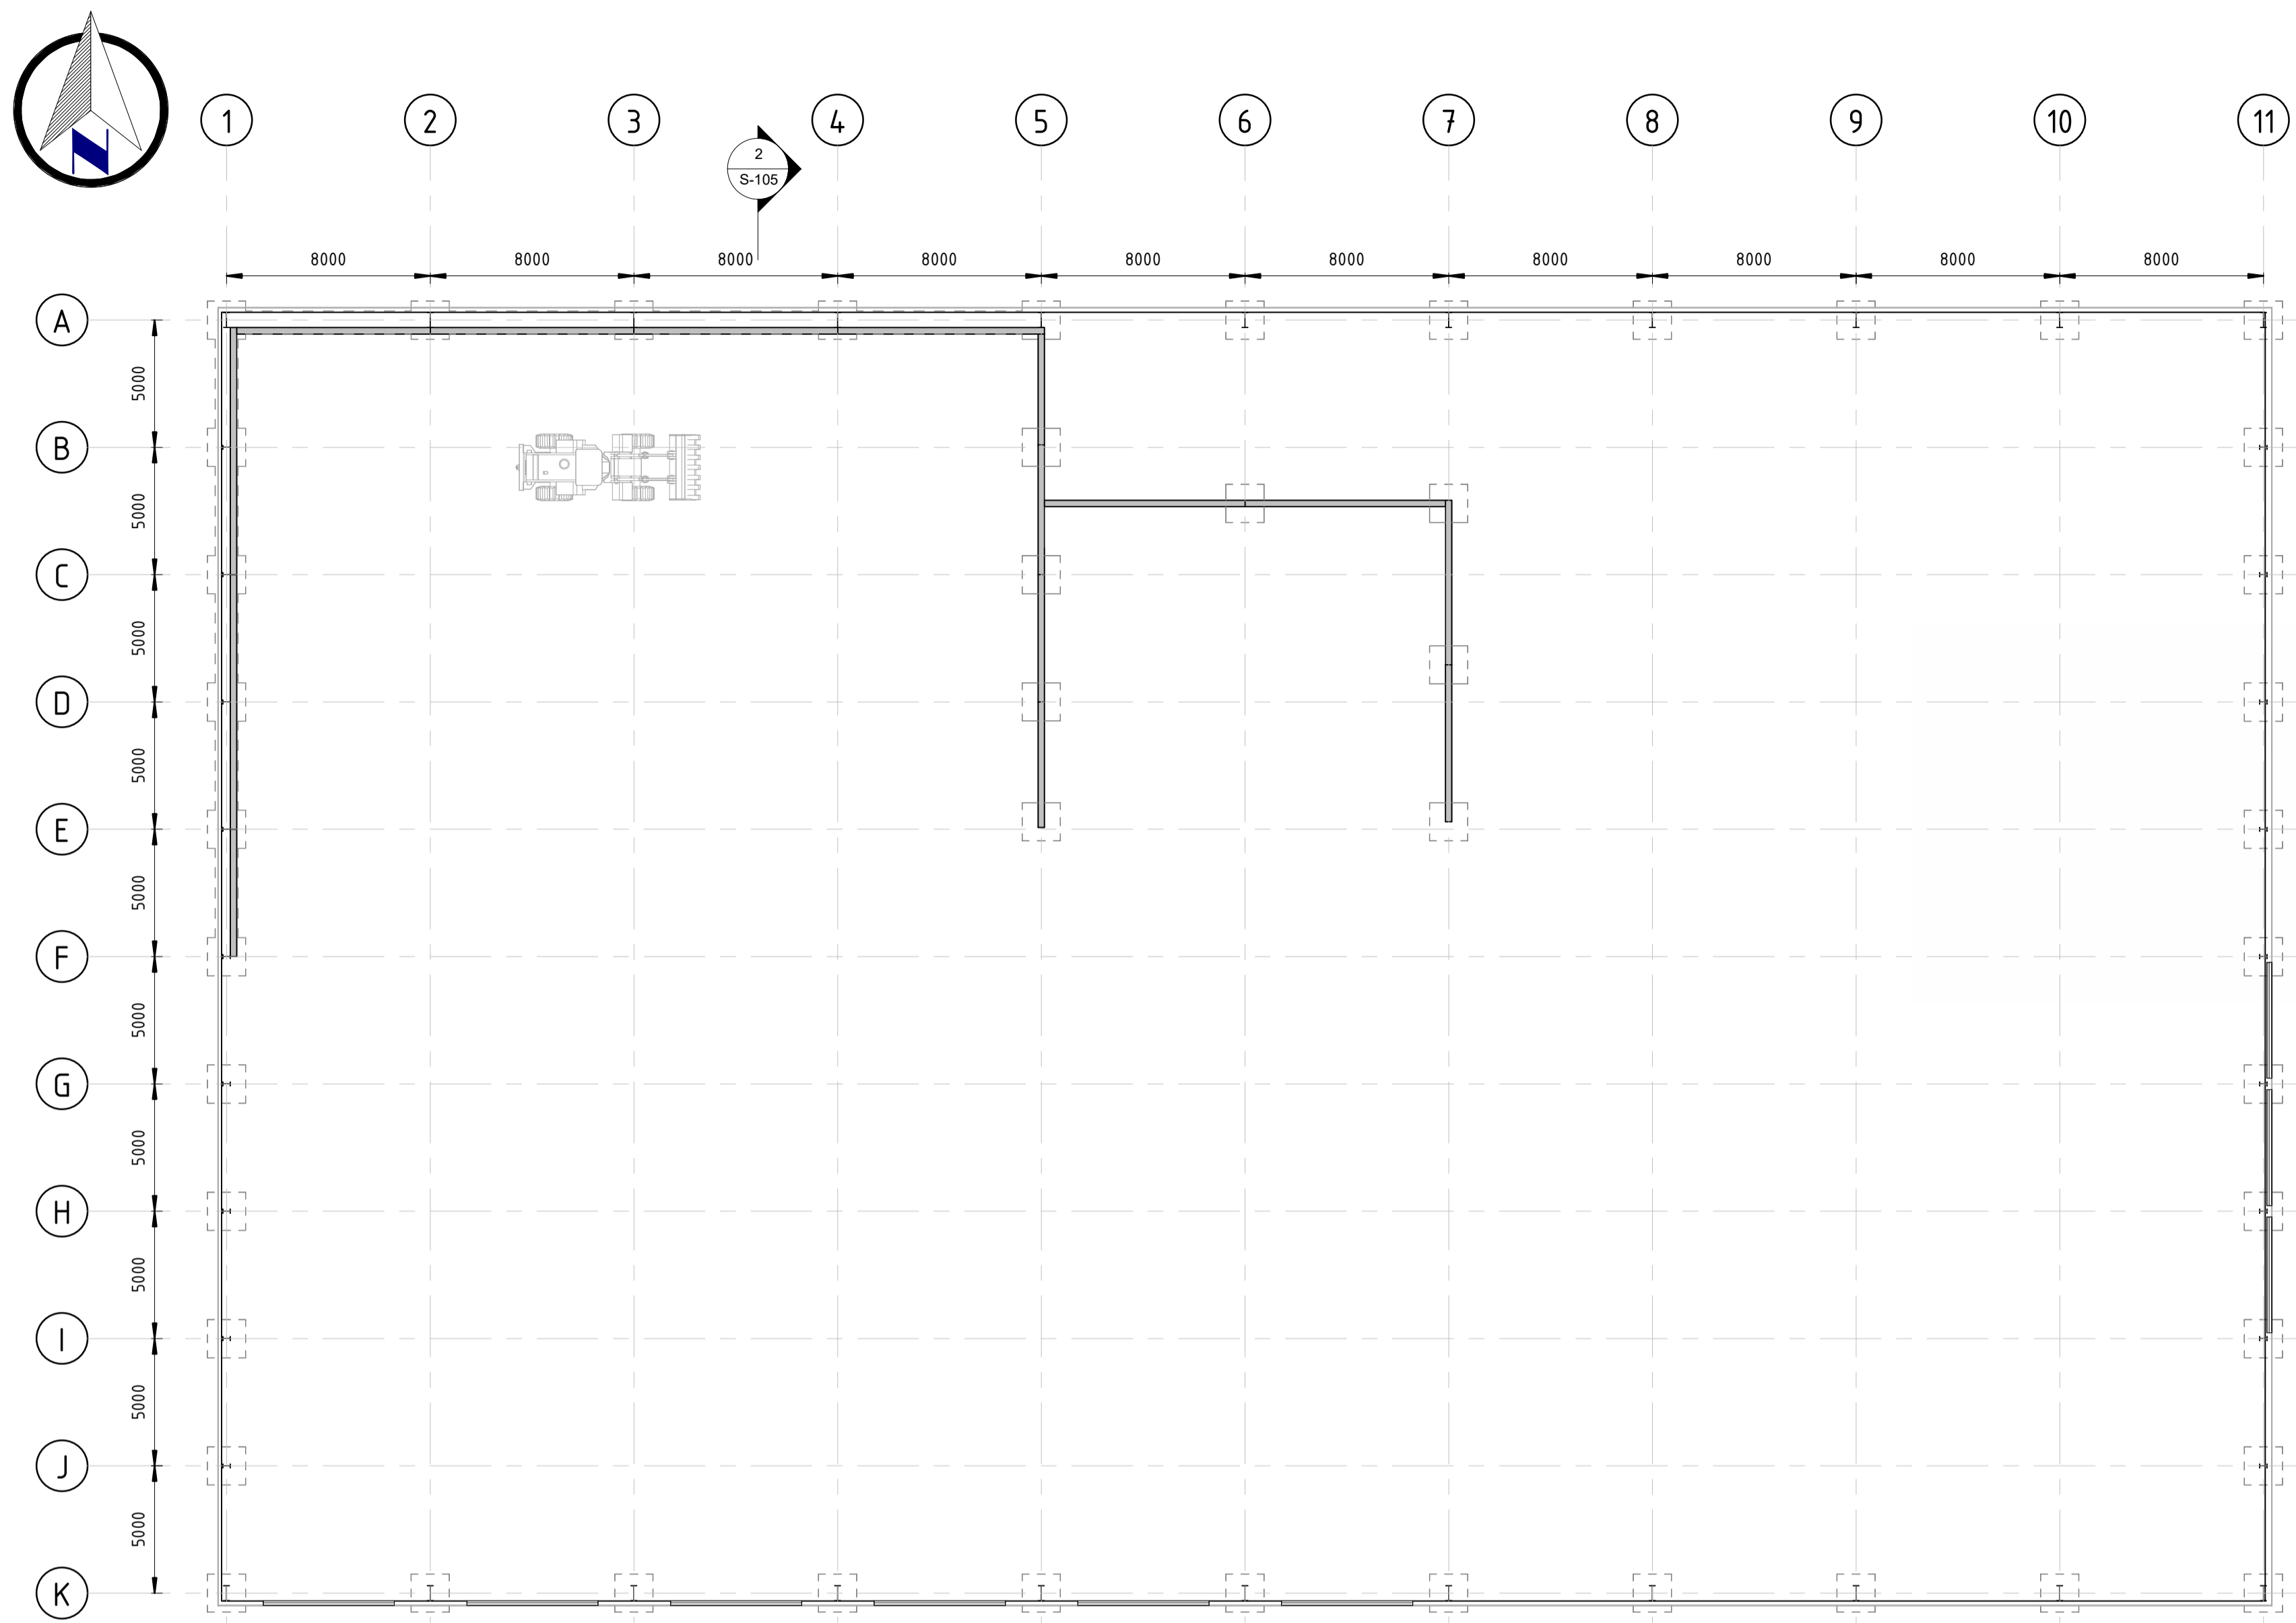

GROUND SLAB LAYOUT
1 : 200

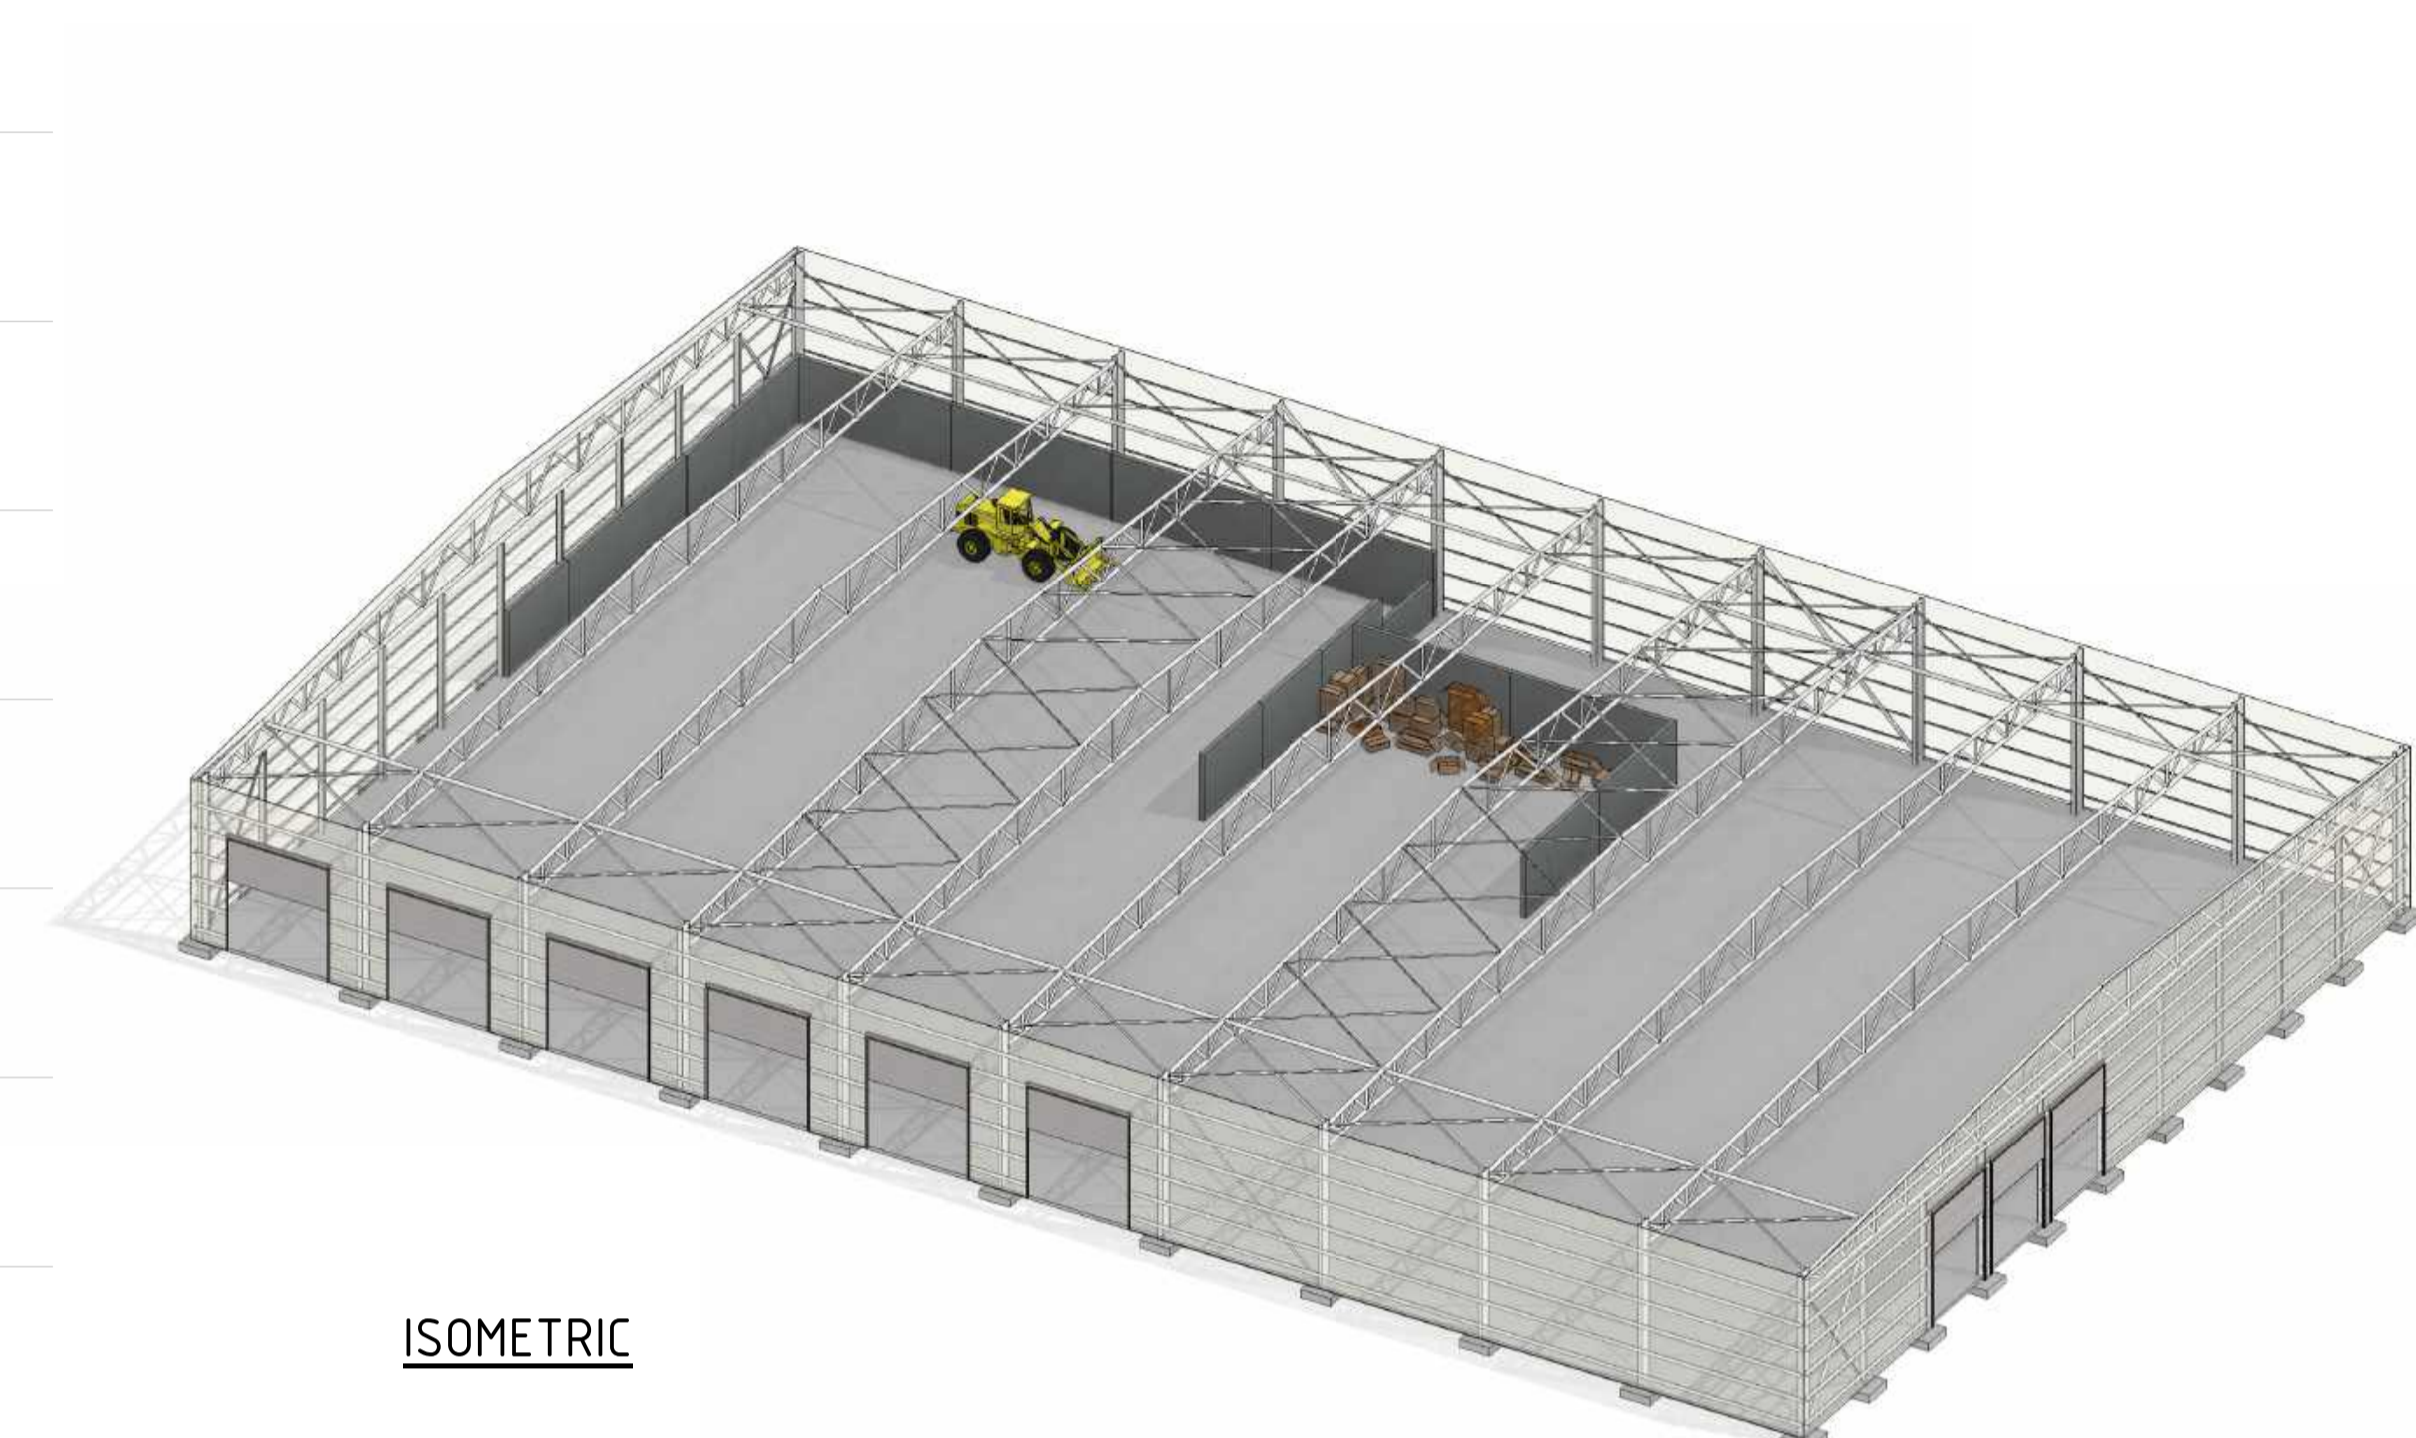

ISOMETRIC

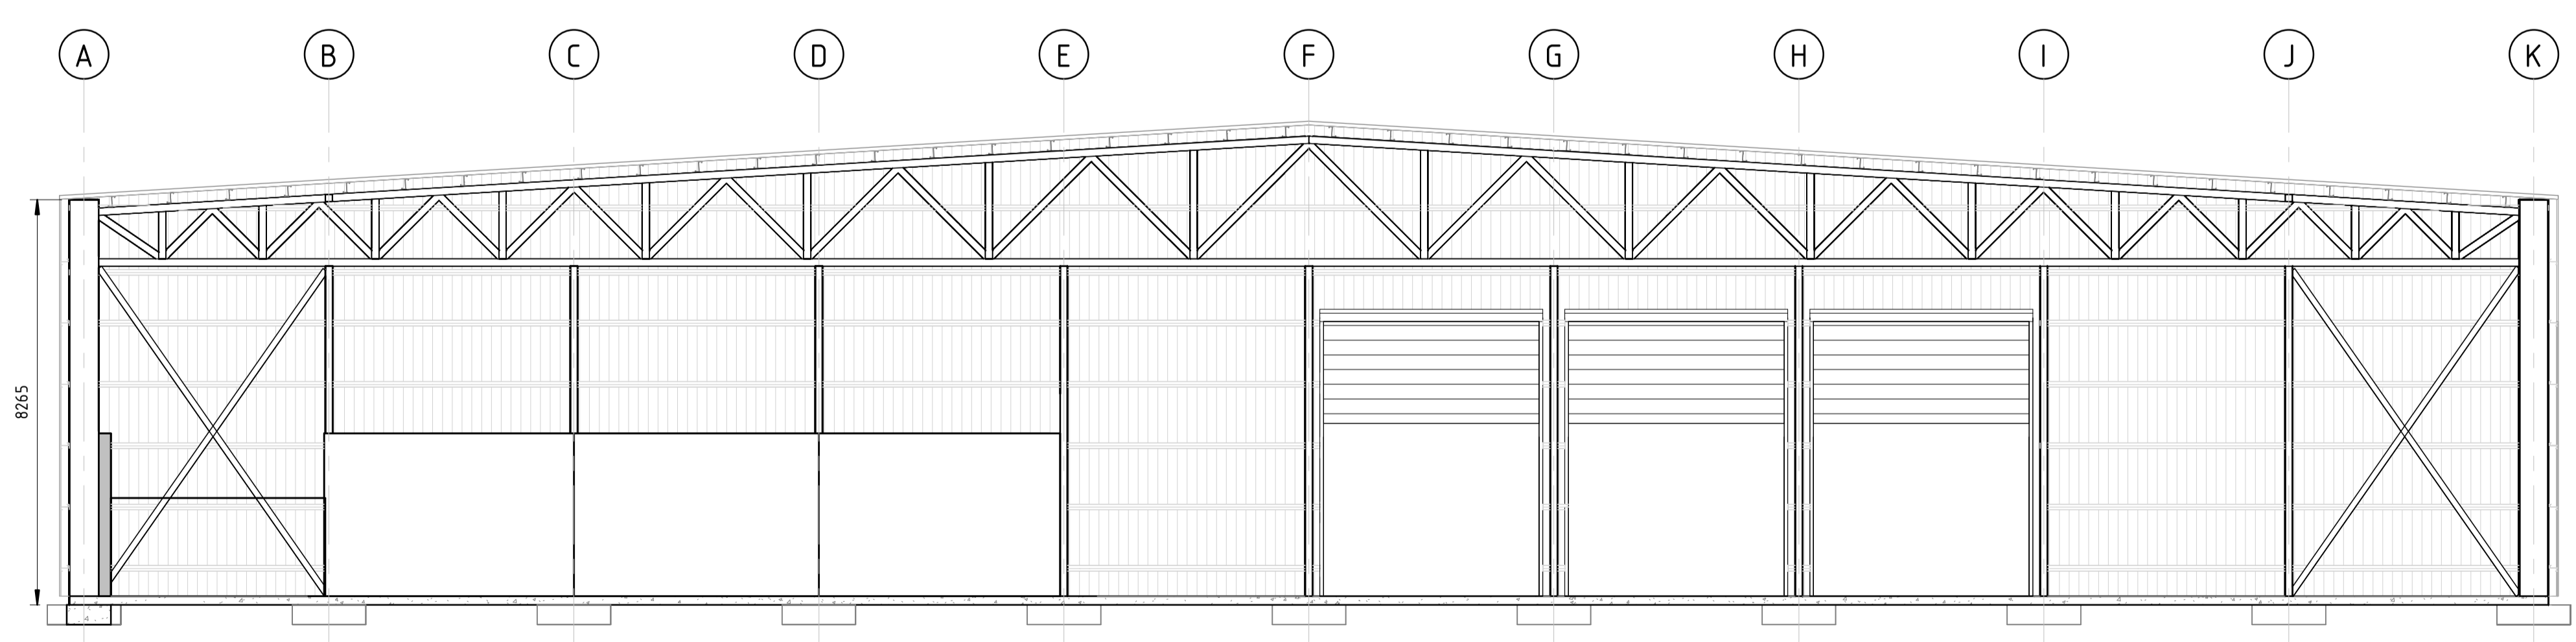


2 SECTION
S-105 SCALE 1 : 100



1:100 @ A1

PRELIMINARY ONLY
NOT FOR CONSTRUCTION

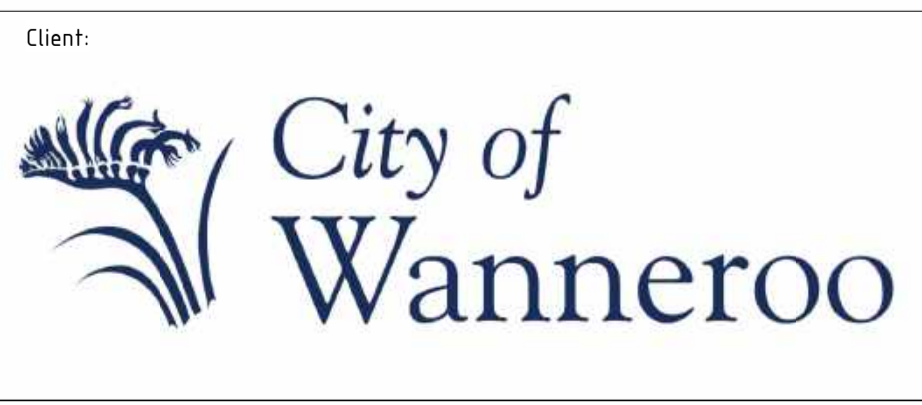

NOTES

1. This drawing is the property of Talis Consultants Pty Ltd. It is a confidential document and must not be copied, used, or its contents divulged without prior written consent.
2. DO NOT SCALE, use figured dimensions only, if in doubt please contact Talis Consultants.
3. Parts of this drawing is intended to be IN COLOUR. Black & White Printing may cause errors or omissions. If this text is not GREEN, please contact Talis Consultants

No.	Date	Dr	Ch	Amendment / Issue

Project: **NRRP - MRF DRAWINGS**

Title: **FLOOR PLAN AND SECTION DRAWINGS**

Scale: AS SHOWN	Date: 09/07/25	
Drawn: CON	Checked: SM	Approved:
Job No: TC25017	Dwg. No: S-105	REV:
Filename: Y:\SECTIONS\Engineering\Projects\TC2025\TC25015 - NRRP Concept Design\Drawings\8_Revit\TC25017 - NRRP MRF Model.rvt		